

St Ignatius' College Riverview


LANE COVE, NSW

Copyright remains the property of Arcadia Design Group Pty Ltd. Use only figured dimensions. Any other required dimensions are to be referred to and supplied by the landscape architect. All discrepancies to be referred to the project manager and Arcadia Design Group Pty Ltd prior to construction. Ensure compliance with the Building Code of Australia and all relevant Australian Standards and Authority requirements.


DRAWING SCHEDULE

DRAWING NO.	DRAWING TITLE
000	COVER SHEET
001	LEGEND
002	MATERIALS SCHEDULE
003	PLANTING SCHEDULE
100	LANDSCAPE MASTER PLAN
201	SETOUT AND GRADING PLAN 1
202	SETOUT AND GRADING PLAN 2
203	SETOUT AND GRADING PLAN 3
204	SETOUT AND GRADING PLAN 4
205	SETOUT AND GRADING PLAN 5
206	SETOUT AND GRADING PLAN 6
207	SETOUT AND GRADING PLAN 7
208	SETOUT AND GRADING PLAN 8
209	SETOUT AND GRADING PLAN 9
301	HARDWORKS PLAN 1
302	HARDWORKS PLAN 2
303	HARDWORKS PLAN 3
304	HARDWORKS PLAN 4
305	HARDWORKS PLAN 5
306	HARDWORKS PLAN 6
307	HARDWORKS PLAN 7
308	HARDWORKS PLAN 8
309	HARDWORKS PLAN 9
401	SOFTWORKS PLAN 1
402	SOFTWORKS PLAN 2
403	SOFTWORKS PLAN 3
404	SOFTWORKS PLAN 4
405	SOFTWORKS PLAN 5
406	SOFTWORKS PLAN 6
407	SOFTWORKS PLAN 7
408	SOFTWORKS PLAN 8
409	SOFTWORKS PLAN 9
501	SECTIONS
502	SECTIONS
503	SECTIONS
600	LANDSCAPE DETAILS - FINISHES
610	LANDSCAPE DETAILS - EDGES
620	LANDSCAPE DETAILS - WALLS
630	LANDSCAPE DETAILS - STAIRS
640	LANDSCAPE DETAILS - HANDRAILS AND FENCES
641	LANDSCAPE DETAILS - HANDRAILS AND FENCES
650	LANDSCAPE DETAILS - FURNITURE
651	LANDSCAPE DETAILS - FURNITURE
652	LANDSCAPE DETAILS - FURNITURE
660	LANDSCAPE DETAILS - STRUCTURES
661	LANDSCAPE DETAILS - STRUCTURES
662	LANDSCAPE DETAILS - STRUCTURES
663	LANDSCAPE DETAILS - STRUCTURES
664	LANDSCAPE DETAILS - STRUCTURES
665	LANDSCAPE DETAILS - STRUCTURES
670	LANDSCAPE DETAILS - SOFTWORKS
671	LANDSCAPE DETAILS - SOFTWORKS
901	LANDSCAPE SPECIFICATION

LOCATION PLAN

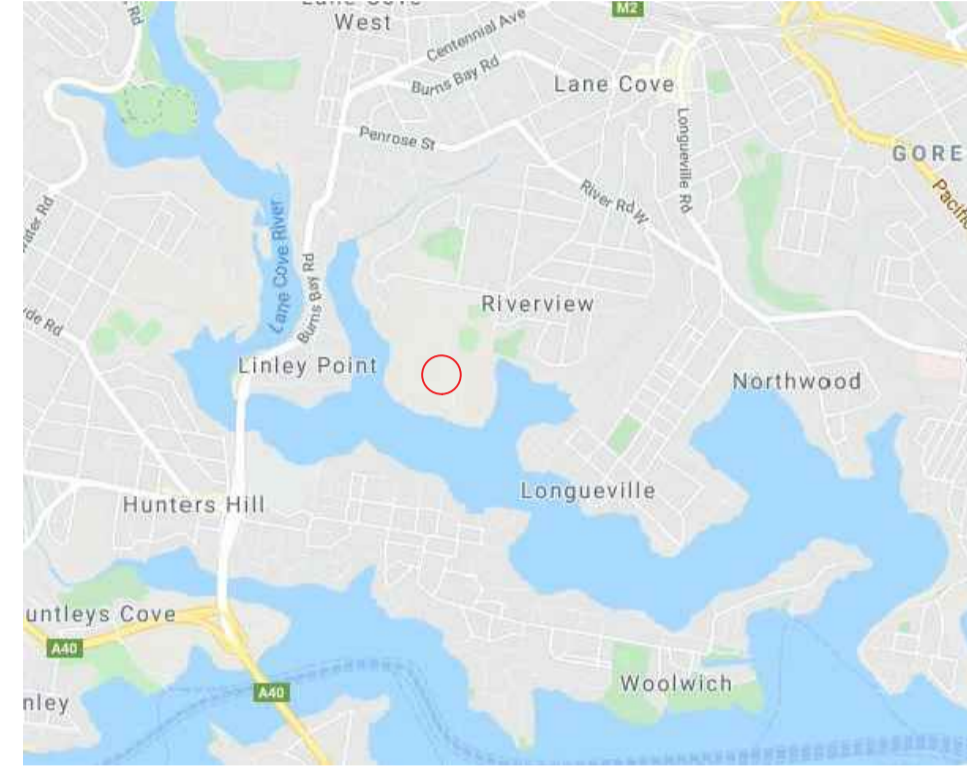

KEYPLAN

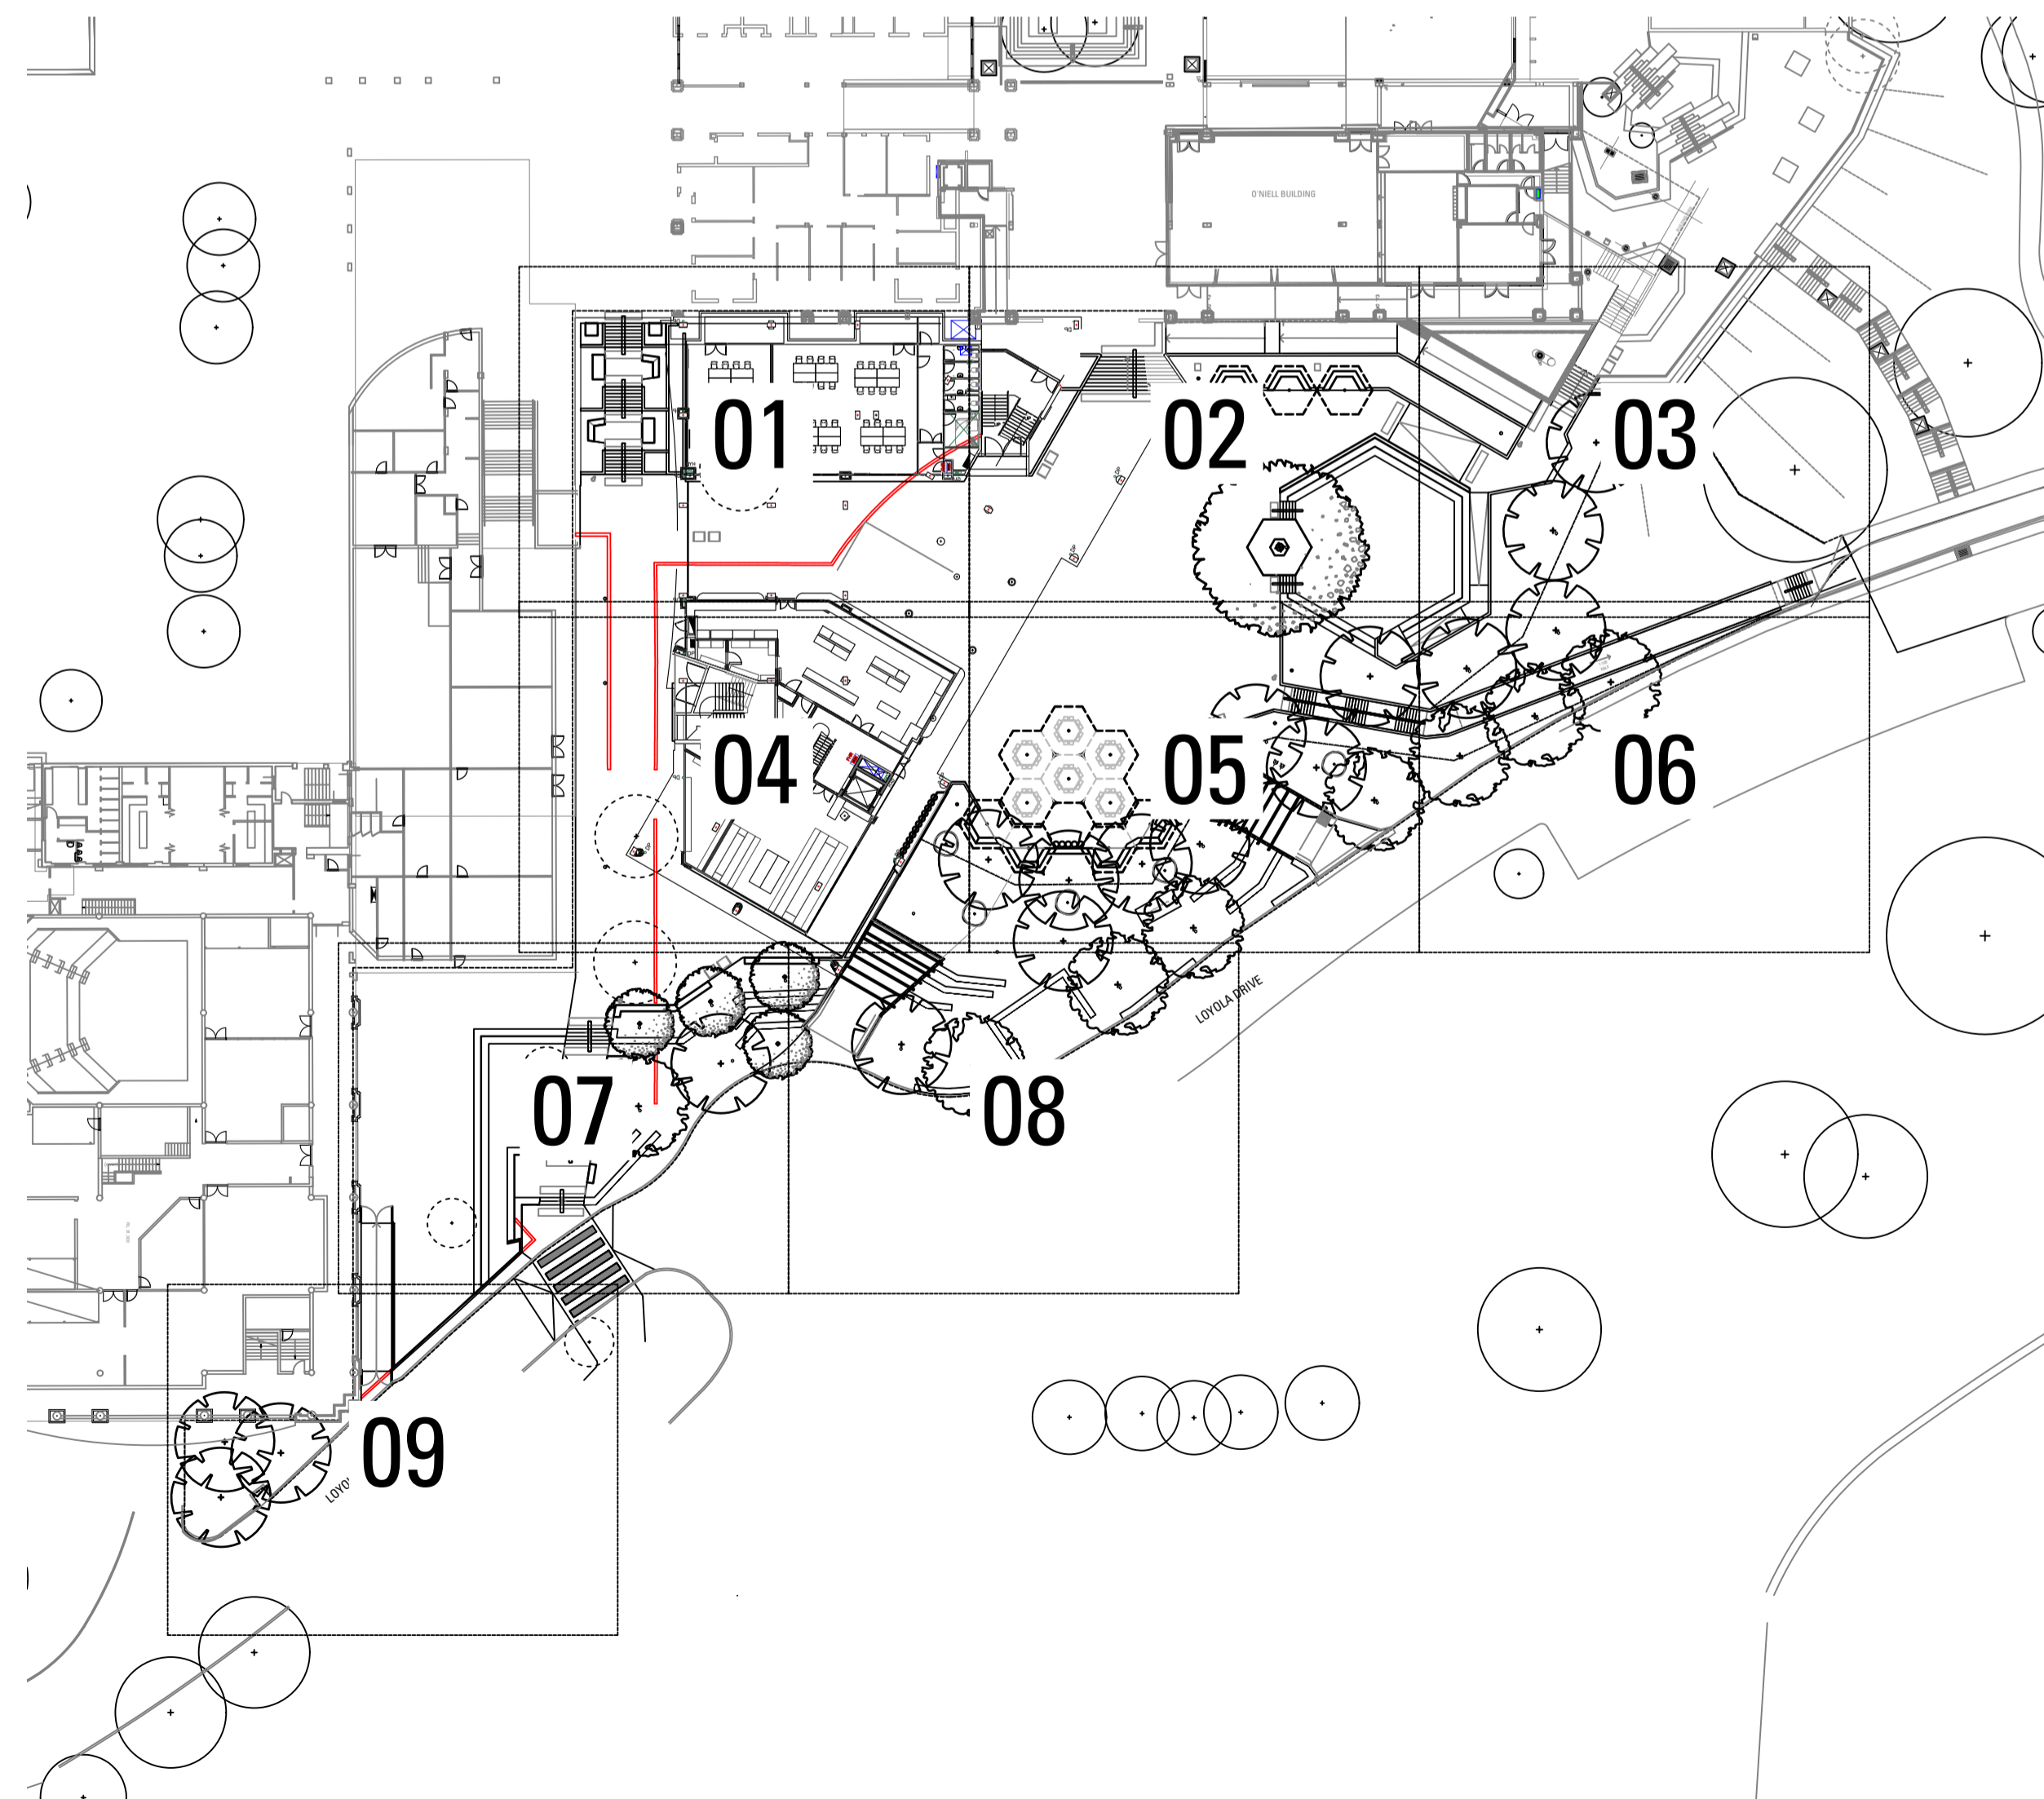

Issue	Revision	Description	Drawn	Check	Date
8		FOR TENDER	CL	AL	14.09.22
7		FOR TENDER	CL	AL	09.09.22
6		FOR TENDER	LM	AL	15.08.22
5		For Coordination	LM	AL	25.07.22
4		For Coordination	LM	AL	21.07.22
3		For Coordination	LM	AL	15.07.22
2		65% For coordination	LM	AL	04.07.22
1		65% DD	LM	AL	20.05.22

Not for Construction

Project
**ST IGNATIUS
RIVERVIEW S2**
LANE COVE NSW
FOR TENDER



 
 

 

Drawing No. 000 Drawing Name COVER SHEET

Job No. 19-655 Issue 8 Scale NTS


 

 




Sydney, Suite 76, Jones Bay Wharf, 26-32 Pirrama Road, Pyrmont NSW 2009 E:sydney@arcadia.com.au T:02 8571 2900



 


 
 
 
 

 
 
 
 



 
 
 
 

 
 


 
 

 
 

 
 
 
 
 

SETOUT LEGEND

-  ANGLE MEASUREMENT
-  DISTANCE MEASUREMENT
-  RADIUS MEASUREMENT
-  SETOUT GUIDES
-  SETOUT MARKER

 











GRADING LEGEND

   -  RL REDUCED LEVEL
-  FFL FINISHED FLOOR LEVEL
-  TS/BS TOP / BOTTOM OF STEP
-  S STEP HEIGHT
-  TW/BW TOP / BOTTOM OF WALL
-  TP TOP OF STORMWATER PIT
-  TOS TOP OF SEAT
-  TR/BR TOP / BOTTOM OF RAMP

 


















HARDWORKS LEGEND

-  LANDSCAPE SCOPE OF WORKS LINE
-  EXISTING ELEMENTS TO BE DEMOLISHED
-  TREES TO BE RETAINED
-  TREES TO BE REMOVED
-  GRANITE UNIT PAVER
Refer Landscape Specification
-  COLOURED CONCRETE PAVE
Refer Landscape Specification
-  OXIDE CONCRETE PAVE
Refer Landscape Specification
-  DECOMPOSED GRANITE PAVE
Refer Landscape Specification
-  COLOURED CONCRETE STAIRS
Refer Landscape Specification
-  CONCRETE STAIRS
Refer Landscape Specification
-  INSITU CONCRETE STAIRS
Refer Landscape Specification
-  CENTRE HANDRAIL
Refer Landscape Specification
-  TACTILE INDICATORS
Refer Landscape Specification
-  CUSTOM SECURITY GATE
Refer Landscape Specification
-  FENCE LINE: CHICKENWIRE
Refer Landscape Specification
-  STEEL EDGE
Refer Landscape Specification
-  STEEL UPSTAND EDGE
Refer Landscape Specification
-  STEEL KERB RAIL
Refer Landscape Specification
-  SANDSTONE RETAINING WALL
Refer Landscape Specification
-  SANDSTONE SEATING WALL
Refer Landscape Specification
-  CONCRETE PLANTER WALL
Refer Landscape Specification
-  TERRACED SANDSTONE WALL
Refer Landscape Specification
-  TIMBER DECK
Refer Landscape Specification
-  TIMBER PLATFORM
Refer Landscape Specification
-  TIMBER PLATFORM
Refer Landscape Specification
-  PRECAST BENCH SEAT
Refer Landscape Specification
-  PRECAST BENCH SEAT
Refer Landscape Specification
-  SANDSTONE SEATING BLOCK
Refer Landscape Specification
-  STUDY BAR
Refer Landscape Specification
-  STUDY BAR SEATS
Refer Landscape Specification
-  SMART TABLES AND SEATS
Refer Landscape Specification
-  RECYCLED TIMBER HOB
Refer Landscape Specification
-  CANOPY 1
Refer Landscape Specification
-  CANOPY 2
Refer Landscape Specification
-  CANOPY 3
Refer Landscape Specification
-  LIGHTING
Refer Lighting Consultant

SOFTWORKS LEGEND

-  EXISTING TREES TO BE RETAINED
Refer Landscape Specification
-  EXISTING TREES TO BE REMOVED
Refer Landscape Specification
-  ANGOPHORA COSTATA
Refer Landscape Specification
-  BANKSIA INTEGRIFOLIA
Refer Landscape Specification
-  CERATOPETALUM GUMMIFERUM
Refer Landscape Specification
-  EUCALYPTUS HAEMASTOMA
Refer Landscape Specification
-  FICUS RUBIGINOSA
Refer Landscape Specification
-  LOPHOSTEMON CONFERTUS
Refer Landscape Specification
-  SHRUB AND ACCENT PLANTING
Refer Landscape Specification
-  GROUNDCOVER PLANTING
Refer Landscape Specification
-  MATRIX 1
Refer Landscape Specification
-  MATRIX 2
Refer Landscape Specification

 MASTERPLAN LEGEND

-  CONCRETE PAVING
Refer Landscape Specification
-  UNIT PAVING
Refer Landscape Specification
-  DECOMPOSED GRANITE PAVING
Refer Landscape Specification
-  GRAVEL PAVING
Refer Landscape Specification
-  TIMBER DECKING
Refer Landscape Specification
-  RETAINING WALL
Refer Landscape Specification
-  TIMBER EDGING
Refer Landscape Specification
-  EXISTING TREES TO BE RETAINED
Refer Landscape Specification
-  EXISTING TREES TO BE REMOVED
Refer Landscape Specification
-  ANGOPHORA COSTATA
Refer Landscape Specification
-  BANKSIA INTEGRIFOLIA
Refer Landscape Specification
-  CERATOPETALUM GUMMIFERUM
Refer Landscape Specification
-  EUCALYPTUS HAEMASTOMA
Refer Landscape Specification
-  FICUS RUBIGINOSA
Refer Landscape Specification
-  LOPHOSTEMON CONFERTUS
Refer Landscape Specification
-  SHRUB AND ACCENT PLANTING
Refer Landscape Specification
-  GROUNDCOVER PLANTING
Refer Landscape Specification
-  MATRIX 1
Refer Landscape Specification
-  MATRIX 2
Refer Landscape Specification

8	FOR TENDER	CL	AL	14.09.22
7	FOR TENDER	CL	AL	09.09.22
6	FOR TENDER	LM	AL	15.08.22
5	For Coordination	LM	AL	25.07.22
4	For Coordination	LM	AL	21.07.22
3	For Coordination	LM	AL	15.07.22
2	65% For coordination	LM	AL	04.07.22
1	65% DD	LM	AL	20.05.22
Issue	Revision Description	Drawn	Check	Date

Not for Construction

Project
ST IGNATIUS RIVERVIEW S2
LANE COVE NSW
 FOR TENDER

Client


Drawing No. 001 Drawing Name LEGEND

Job No. 19-655 Issue 8 Scale NTS

Sydney, Suite 76, Jones Bay Wharf, 26-32 Pirrama Road, Pyrmont NSW 2009 E:sydney@arcadia.com.au T:02 8571 2900



19-655 RIVERVIEW STAGE 2 - MATERIALS SCHEDULE						
CODE	TYPE	DETAIL	LOCATION	PRODUCT INFORMATION	MATERIAL	CONSTRUCTION NOTES
PAVING & SURFACES						
P1	Granite Unit Paving		Refer landscape plans	Product: Precast Granite (Ivory Black) - to match Therry building Dimensions: 500 x 250 x min 30mm depth Finish: Exfoliated finish	Large format stone paver, butt jointed	Refer Landscape detail & specification
P2	Coloured Concrete with Line marking		Refer landscape plans	Product: Coloured concrete (Neutral tones with peach/sandstone oxide) with feature aggregate Dimensions: 100mm depth	Concrete paving to engineers specification	Refer Landscape detail & specification
P3	Insitu Concrete Paving with Dark Oxide		Refer landscape plans	Product: Dark Oxide - CCS obsidian Dimensions: 100mm depth Finish: Exposed finish, bonded, slip resistant	Insitu concrete paving to engineers specification	Refer Landscape detail & specification
P4	Decomposed Granite Paving		Refer landscape plans	Product: Decomposed granite, mix brown and gold	Decomposed granite, un-stabilised with 5% cement mix	Refer Landscape detail & specification
EDGE						
E1	Steel Edge		Refer landscape plans	Galvanised Mild Steel Dimensions: Refer Landscape Detail	Galvanised Mild Steel	Refer Landscape detail & specification
E2	Steel Upstand Edge		Refer landscape plans	Galvanised Mild Steel Dimensions: Refer Landscape Detail	Galvanised Mild Steel	Refer Landscape detail & specification
WALLS						
W1 a	Sandstone Retaining Wall		Refer landscape plans	Product: A grade sandstone Supplier: Gosford Quarries A grade Dimensions: 200x500x500mm Finish: Quarry Sawm, split face	Sandstone Equal to Gosford Quarries	Refer Landscape detail & specification
W1 b	Sandstone Seating Retaining Wall		Refer landscape plans	Product: A grade sandstone Supplier: Gosford Quarries A grade Dimensions: 200x500x500mm Finish: Quarry Sawm, split face	Sandstone Equal to Gosford Quarries	Refer Landscape detail & specification
W2	Formed Concrete Plaster Wall - 200mm		Refer landscape plans	Product: C8 form precast concrete Supplier: 2 Barrows Finish: Class 2 finish Chamber: Round 10mm chamfer to top edges	Concrete to Engineers specification	Refer Landscape detail & specification
W3	Sandstone Seating Wall		Refer landscape plans	Product: A grade sandstone Supplier: Gosford Quarries A grade Dimensions: 200x500x500mm Finish: Quarry Sawm, split face	Sandstone Equal to Gosford Quarries	Refer Landscape detail & specification
STEPS						
ST1	Coloured Concrete		Refer landscape plans	Product: Coloured concrete (Neutral tones with peach/sandstone oxide) with feature aggregate Finish: Washed / Exposed finish	Stairs in cladding P1 paving	Refer Landscape detail & specification
ST2	Insitu Concrete Steps with Granite Cladding		Refer landscape plans	Product: Precast Granite (Ivory Black) - to match Therry building Dimensions: min 140mm depth Finish: Exfoliated finish, butt jointed	Stairs in cladding P2 paving	Refer Landscape detail & specification
ST3	Insitu Concrete Steps with Dark Oxide		Refer landscape plans	Product: Dark Oxide - CCS colour TBC Finish: Washed / Exposed finish	Stairs in cladding P3 paving	Refer Landscape detail & specification

HANDRAILS, & BALUSTRADES						
H1	Centre Free Standing Handrail		Refer landscape plans	Product: Steel Central Handrail Finish: Galvanised steel, 45Dia	Galvanised steel	Refer Landscape detail & specification
H2	Free standing wall mounted		Refer landscape plans	Product: Steel Wall Mounted Handrail Finish: Galvanised steel, 45Dia	Galvanised steel	Refer Landscape detail & specification
BALI	Steel Balustrade		Refer landscape plans	Product: Galvanised steel balustrade Custom to match therry garden	Galvanised steel	Refer Landscape detail & specification
FE1	Timber Post Fence		Refer landscape plans	Product: 100 x 100mm Timber Post with wire	Hardwood Post	Refer Landscape detail & specification
STRUCTURES						
ST01	Canopy 01		Refer landscape plans	Product: Custom large structure with steel, perforated glass panels, weatherproof Dimensions: Refer Detail	Steel frame, Glass top and perforated underside. Drainage incorporated	Refer Landscape detail & specification
ST02	Canopy 02		Refer landscape plans	Product: Custom large structure with steel, perforated glass panels, weatherproof Dimensions: Refer Detail	Steel frame, Glass top and perforated underside. Drainage incorporated	Refer Landscape detail & specification
ST03	Canopy 03		Refer landscape plans	Product: Custom large structure with steel, perforated glass panels, weatherproof Dimensions: Refer Detail	Steel frame, Glass top and perforated underside. Drainage incorporated	Refer Landscape detail & specification
ST04	Arbour Structure		Refer landscape plans	Product: Custom SHS Steel arbor structure with tensile fixings and vegetation climbing trellis Supplier: To custom manufacture	Powdercoated Steel Arbor	
TD	Raised Timber Deck		Refer landscape plans	Product: 140 x 20mm, 8mm gapping Dimensions: Refer landscape details	Hardwood timber (spotted gum), joists + bearers to engineers spec	Refer Landscape detail & specification
FIXTURES						
TGSI	Tactile Indicators		Refer landscape plans	Galvanised steel Product: Safespot 'Millenium' range Supplier: Safespot	Galvanised steel	Refer Landscape detail & specification
Sn	Step Nosings		Refer landscape plans, to all stairs	Galvanised steel Product: Korb 'Tadao' range 122510 50x3mm recessed Supplier: Korb	Galvanised steel	Refer Landscape detail & specification
FURNITURE						
F1 a	Timber Platform Small		Refer landscape plans	Product: 140 x 20mm, 8mm gapping Dimensions: Refer landscape details	Hardwood Timber, powdercoated steel frame, galvanised fixings	Refer Landscape detail and specification
F1 b	Timber Platform Large		Refer landscape plans	Product: 140 x 20mm, 8mm gapping Dimensions: Refer landscape details	Hardwood Timber, powdercoated steel frame, galvanised fixings	Refer Landscape detail and specification
F2	Precast Bench		Refer landscape plans	Product: Equal to 2barrows precast concrete Dimensions: Refer landscape details	Precast Concrete Shot Blast Finish	Refer Landscape detail and specification
F3	Precast Bench		Refer landscape plans	Product: Equal to 2barrows precast concrete Dimensions: Refer landscape details	Precast Concrete Shot Blast Finish	Refer Landscape detail and specification
F4	Sandstone Block seat		Refer landscape plans	Product: Gosford Quarries A grade Sandstone blocks Dimensions: Refer landscape details Finish: Smooth top, exfoliated face	Sandstone hob	Refer Landscape detail and specification
F5	Precast Bar		Refer landscape plans	Product: Precast concrete bar top Dimensions: Refer landscape details	Precast Concrete Shot Blast Finish	Refer Landscape detail and specification
F6	Bar Seats		Refer landscape plans	Product: Custom Steel Bar Seat Dimensions: Refer landscape details Finish: Powdercoated Colour TBC	Powdercoated steel and galvanised fixings	Refer Landscape detail and specification
F7	Smart tables and Chairs		Refer landscape plans	Product: Custom TBC Dimensions: Refer landscape details Finish: Powdercoated Colour TBC Services: 3 x double GPO per table	Steel smart tables with integrated GPO, 240 Phase Power and AV Ports. Further design finalisation to be done in collaboration with manufacturer.	Refer Landscape detail and specification
F8	Kennedy Recycled Timber Hob		Refer landscape plans	Product: Harbour side Recycled Timber Hob Supplier: Kennedy's Timber Dimensions: Refer landscape details Finish: 300 x 300 recycled hardwood	Recycled Hardwood Timber	Refer Landscape specification
WB	Water Bubbler		Refer landscape plans	Product: BF200 Water Bottle Refill Fountain Supplier: Urban+ Finish: Powdercoat with anti graffiti coating	Fully welded steel	Refer Landscape specification
BIN	Rubbish Bin		Refer landscape plans	Product: Wharf Bin (Modified) Supplier: StraBe Finish: Powdercoated	Powdercoated Mild Steel, Spotted Gum Slats	Refer Landscape specification
LIGHTING						
L1	Garden Up Light		Refer preliminary landscape lighting plans	Product: Equal to 'Underacore InOut' Supplier: Guzini	Warm white (nom 3000K)	To electrical engineers specification
L2	Structure Mounted Light		Refer preliminary landscape lighting plans	Product: Equal to 'Light Up' Supplier: Guzini	Warm white (nom 3000K)	To electrical engineers specification
L3	Strip Light		Refer preliminary landscape lighting plans	Product: Equal to 'Linealuce' Supplier: Guzini	Warm white (nom 3000K)	To electrical engineers specification
L4	Post Light - Directional		Refer preliminary landscape lighting plans	Product: Equal to 'Underacore InOut' Supplier: Guzini	Warm white (nom 3000K)	To electrical engineers specification
L5	Post Light - Array		Refer preliminary landscape lighting plans	Product: Equal to 'Flamma' Supplier: Guzini	Warm white (nom 3000K)	To electrical engineers specification

8	FOR TENDER	CL	AL	14.09.22		
7	FOR TENDER	CL	AL	09.09.22		
6	FOR TENDER	LM	AL	15.08.22		
5	For Coordination	LM	AL	25.07.22		
4	For Coordination	LM	AL	21.07.22		
3	For Coordination	LM	AL	15.07.22		
2	65% For coordination	LM	AL	04.07.22		
1	65% DD	LM	AL	20.05.22		
	Issue	Revision	Description	Drawn	Check	Date

Not for Construction

Project
ST IGNATIUS
RIVERVIEW S2
LANE COVE NSW
 FOR TENDER



Drawing No. 002 Drawing Name MATERIALS SCHEDULE

Job No. 19-655 Issue 8 Scale NTS

Sydney, Suite 76, Jones Bay Wharf, 26-32 Pirrama Road, Pyrmont NSW 2009 E:sydney@arcadia.com.au T:02 8571 2900



19-655 RIVERVIEW S2 PLANT SCHEDULE					
CODE	BOTANIC NAME	COMMON NAME	MATURE SIZE (h x w) (m)	PROPOSED POT SIZE	QUANTITY
TREES & PALMS					
Ac	<i>Angophora costata</i>	Smooth-Barked Apple	20 x 10	200L	8
Bi	<i>Banksia integrifolia</i>		12 x 7		4
Cg	<i>Ceratopetalum gummiferum</i>	New South Wales Christmas bush	5m h	75L	5
Eh	<i>Eucalyptus haemastoma</i>	Scribbly Gum	15 x 10	200L	17
Fr	<i>Ficus rubiginosa</i>	Port Jackson Fig	30 x 10	2000L	1
Lc	<i>Lophostemon confertus</i>	Brush Box	15 x 10	200L	2
SHRUBS & ACCENTS					
Asu	<i>Acacia suaveolens</i>	Sweet-scented Wattle	2 x 1	150mm	84
Bgg	<i>Banksia ericifolia</i>	Heath-Leaved Banksia	1.5 x 1.5	25L	91
Dt	<i>Dodonaea triquetra</i>	Forest Hop Bush	3m h	200mm	30
Gl	<i>Grevillea linearifolia</i>	White Spider Flower	2 x 2	150mm	65
Pf	<i>Platylobium formosum</i>	Handsome Flat-pea	2m h	200mm	44
Ps	<i>Polyscias sambucifolia</i>	Elderberry panax	3m h	200mm	15
Xt	<i>Xanthorrhoea Species</i>	Grass Tree	2 x 1	100cm Trunk	12
Cdb	<i>Correa reflexa</i>	Common Correa	1 x 1	25L	41
Lp	<i>Leptospermum polygalifolium</i>	Lemon-scented Tea Tree	1.5 x 2	25L	27
GRASSES & RUSHES					
Dr	<i>Dianella Spp.</i>	Spreading Flax Lily	1 x 1.5	150mm	385
FERNS & CYCADS					
Mc	<i>Macrozamia communis</i>	Burrawong	1.5 x 2	150mm	112
Bc	<i>Blechnum cartilagineum</i>	Soft Water Fern	1 x 1	150mm	330
Ad	<i>Adiantum aethiopicum</i>	Maidenhair Fern	0.5 x 0.5	150mm	157
Aa	<i>Asplenium australasicum</i>	Birds Nest Fern	1.5 x 1.5	200mm	26
Br	<i>Bromeliad Species</i>	Bromeliad	1 x 1	200mm	32
Md	<i>Microsorium diversifolium</i>	Kangaroo Paw Fern	1 x 1	200mm	76
Hm	<i>Hypolepis muelleri</i>	Ground Fern	1m h	150mm	33
GROUNDCOVERS & CLIMBERS					
Hv	<i>Hardenbergia violacea</i>	False Sarsaparilla	0.25 x spreading	150mm	40
Dsf	<i>Dichondra repens</i>	Kidney Weed	0.2 x spreading	150mm	40
Vh	<i>Viola hederacea</i>	Native Violet	0.2 x 0.5	150mm	589
MATRIX 01					
Dr	<i>Dianella Spp.</i>	Spreading Flax Lily	1 x 1.5	150mm	848 (6/m2)
Es	<i>Entolasia stricta</i>	Wiry Panic	0.8m h	150mm	1134 (8/m2)
Lla	<i>Lepidosperma laterale</i>	Variable Swordsedge	1m h	150mm	848 (6/m2)
Ms	<i>Microlaena stipoides</i>	Weeping Grass	0.7m h	150mm	565 (4/m2)
Ta	<i>Themeda australis</i>	Kangaroo Grass	1 x 1	150mm	1134 (8/m2)
MATRIX 02					
LI	<i>Lomandra longifolia</i>	Spiny Headed Mat Rush	1 x 1	150mm	562 (6/m2)
Pg	<i>Patersonia glabrata</i>	Leafy Purple Flag	0.5 x 0.5	200mm	749 (6/m2)
Pa	<i>Poa affinis</i>	Tussock Grass	1m h	150mm	562 (6/m2)
Lh	<i>Lomandra hystrix</i>	Mat Rush	1.5 x 1.5	150mm	374 (6/m2)
Bs	<i>Billardiera scandens</i>	Apple Berry	1.5 x Spreading	150mm	562 (6/m2)

8

8	FOR TENDER	CL	AL	14.09.22
7	FOR TENDER	CL	AL	09.09.22
6	FOR TENDER	LM	AL	15.08.22
5	For Coordination	LM	AL	25.07.22
4	For Coordination	LM	AL	21.07.22
3	For Coordination	LM	AL	15.07.22
2	65% For coordination	LM	AL	04.07.22
1	65% DD	LM	AL	20.05.22

Issue Revision Description Drawn Check Date

Not for Construction

Project
**ST IGNATIUS
 RIVERVIEW S2
 LANE COVE NSW**
 FOR TENDER




Drawing No. 003 Drawing Name PLANTING SCHEDULE

Job No. 19-655 Issue 8 Scale NTS

Sydney, Suite 76, Jones Bay
 Wharf, 26-32 Pirrama Road,
 Pyrmont NSW 2009
 E sydney@arcadia.com.au
 T 02 8571 2900

ARCADIA

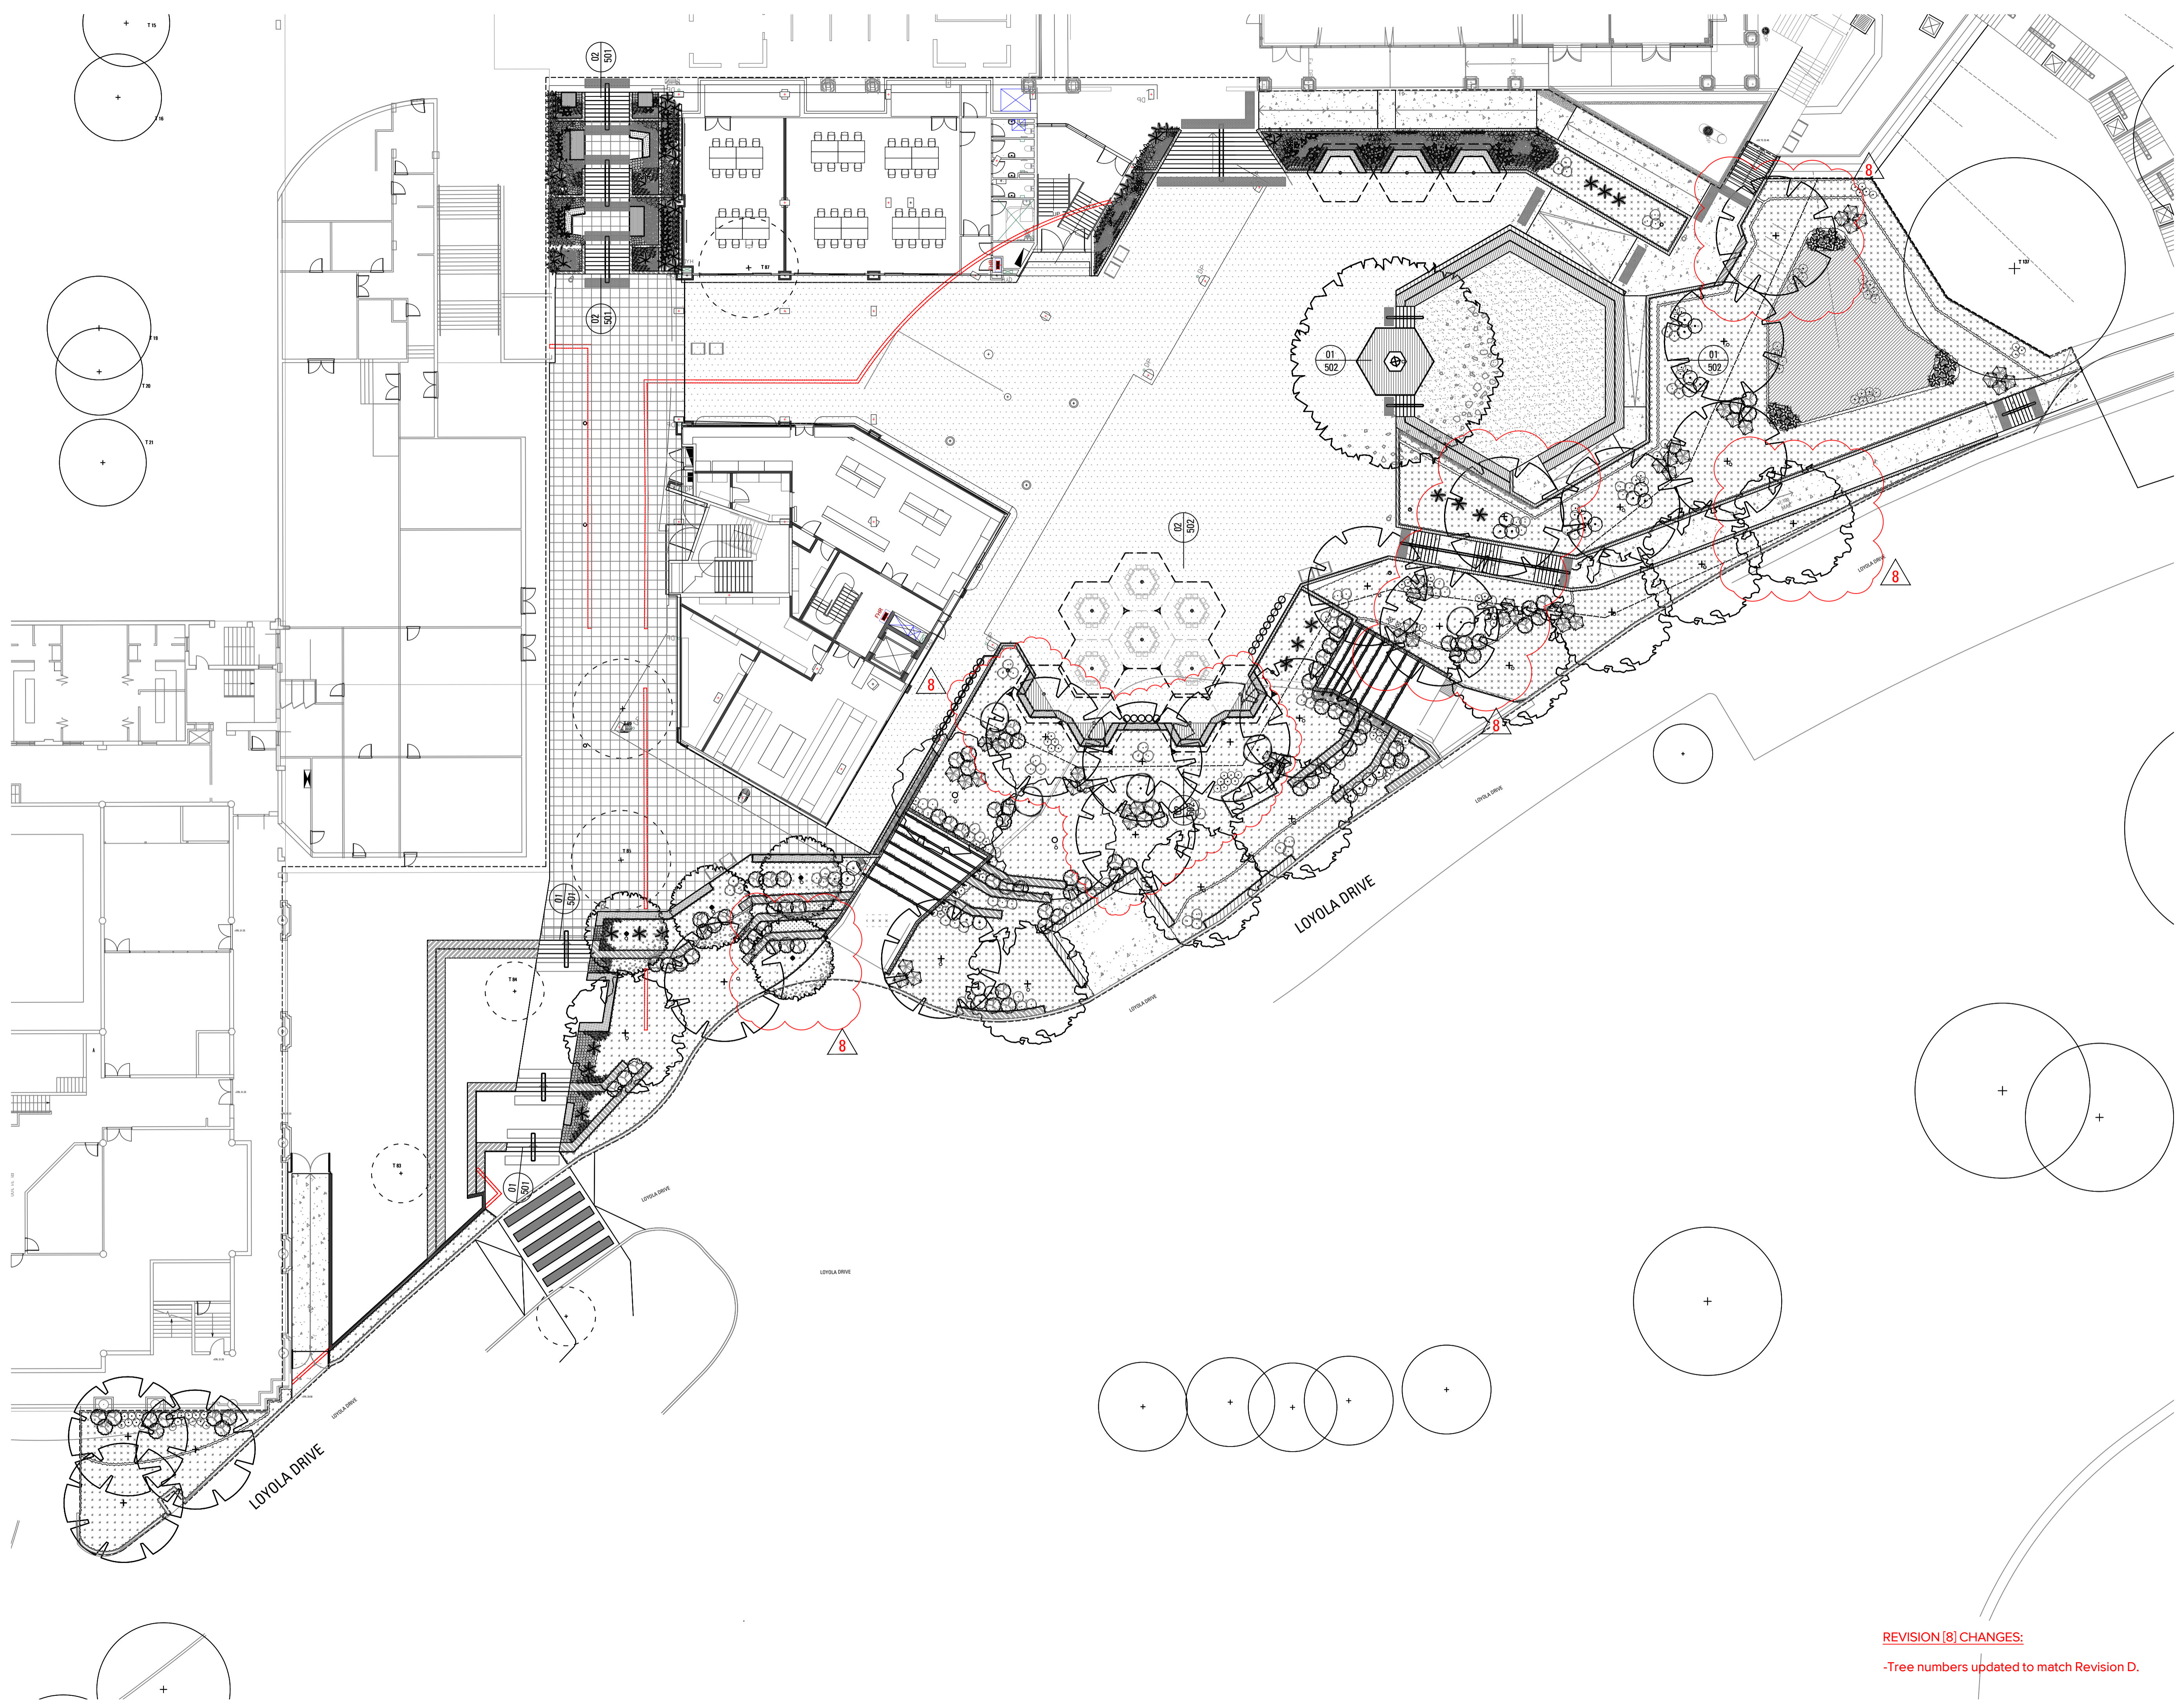

- MASTERPLAN LEGEND**
- CONCRETE PAVING
Refer Landscape Specification
 - UNIT PAVING
Refer Landscape Specification
 - DECOMPOSED GRANITE PAVING
Refer Landscape Specification
 - GRAVEL PAVING
Refer Landscape Specification
 - TIMBER DECKING
Refer Landscape Specification
 - RETAINING WALL
Refer Landscape Specification
 - TIMBER EDGING
Refer Landscape Specification
 - EXISTING TREES TO BE RETAINED
Refer Landscape Specification
 - EXISTING TREES TO BE REMOVED
Refer Landscape Specification
 - ANGOPHORA COSTATA
Refer Landscape Specification
 - BANKSIA INTEGRIFOLIA
Refer Landscape Specification
 - CERATOPETALUM GUMMIFERUM
Refer Landscape Specification
 - EUCALYPTUS HAEMASTOMA
Refer Landscape Specification
 - FICUS RUBIGINOSA
Refer Landscape Specification
 - LOPHOSTEMON CONFERTUS
Refer Landscape Specification
 - SHRUB AND ACCENT PLANTING
Refer Landscape Specification
 - GROUNDCOVER PLANTING
Refer Landscape Specification
 - MATRIX 1
Refer Landscape Specification
 - MATRIX 2
Refer Landscape Specification

Issue	Revision Description	Drawn	Check	Date
8	FOR TENDER	CL	AL	14.09.22
7	FOR TENDER	CL	AL	09.09.22
6	FOR TENDER	LM	AL	15.08.22
5	For Coordination	LM	AL	25.07.22
4	For Coordination	LM	AL	21.07.22
3	For Coordination	LM	AL	15.07.22
2	65% For coordination	LM	AL	04.07.22
1	65% DD	LM	AL	20.05.22

Not for Construction

Project
ST IGNATIUS RIVERVIEW S2
LANE COVE NSW
 FOR TENDER

Client
 Saint Ignatius College RIVERVIEW

Drawing No. 100 Drawing Name LANDSCAPE STAGE 2 MASTER PLAN

 
 










Job No. 19-655 Issue 8 Scale 1:200 A1



Sydney, Suite 76, Jones Bay Wharf, 26-32 Pirrama Road, Pyrmont NSW 2009 E:sydney@arcadia.com.au T:02 8571 2900



REVISION [8] CHANGES:
 -Tree numbers updated to match Revision D.

Copyright remains the property of Arcadia Design Group Pty Ltd. Use only figured dimensions. Any other required dimensions are to be referred to and supplied by the landscape architect. All discrepancies to be referred to the project manager and Arcadia Design Group Pty Ltd prior to construction. Ensure compliance with the Building Code of Australia and all relevant Australian Standards and Authority requirements.

- SOFTWORKS LEGEND**
-  EXISTING TREES TO BE RETAINED
Refer Landscape Specification
 -  EXISTING TREES TO BE REMOVED
Refer Landscape Specification
 -  ANGOPHORA COSTATA
Refer Landscape Specification
 -  BANKSIA INTEGRIFOLIA
Refer Landscape Specification
 -  CERATOPETALUM GUMMIFERUM
Refer Landscape Specification
 -  EUCALYPTUS HAEMASTOMA
Refer Landscape Specification
 -  FICUS RUBIGINOSA
Refer Landscape Specification
 -  LOPHOSTEMON CONFERTUS
Refer Landscape Specification
 -  SHRUB AND ACCENT PLANTING
Refer Landscape Specification
 -  GROUNDCOVER PLANTING
Refer Landscape Specification
 -  MATRIX 1
Refer Landscape Specification
 -  MATRIX 2
Refer Landscape Specification

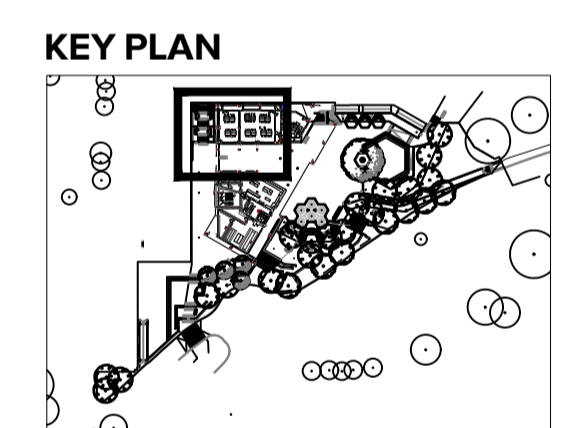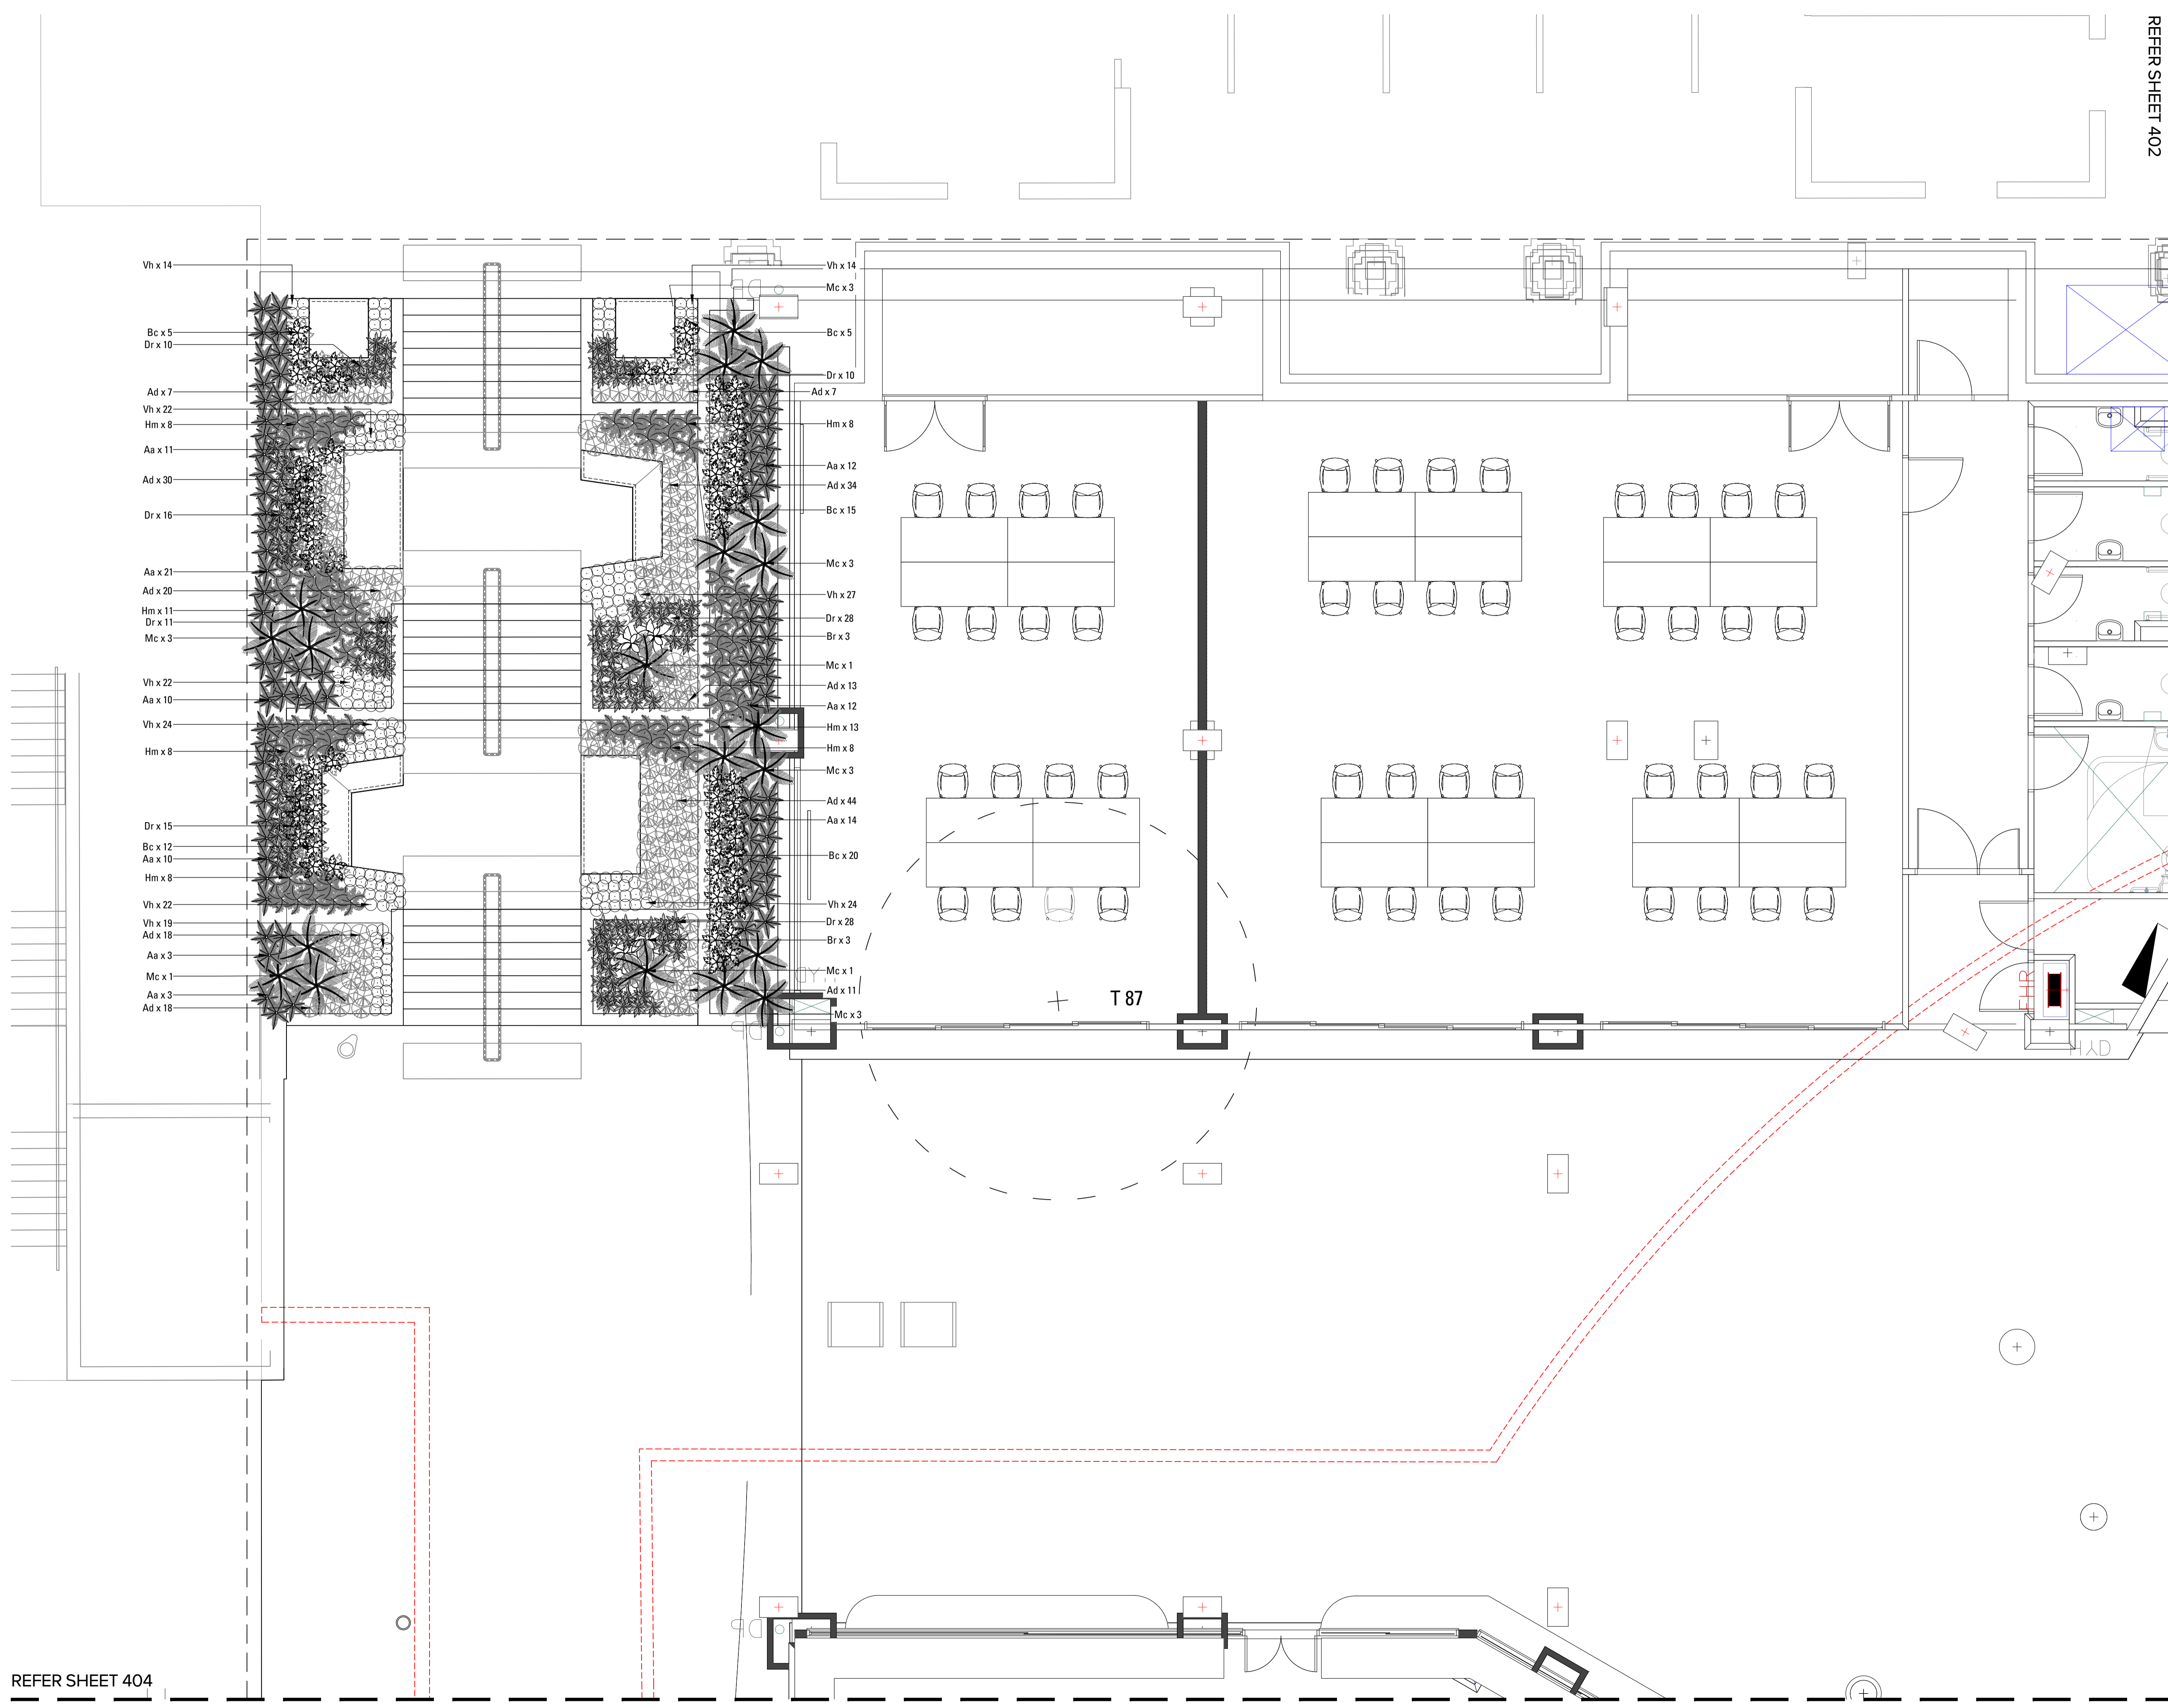

Issue	Revision Description	Drawn	Check	Date
8	FOR TENDER	CL	AL	14.09.22
7	FOR TENDER	CL	AL	09.09.22
6	FOR TENDER	LM	AL	15.08.22
5	For Coordination	LM	AL	25.07.22
4	For Coordination	LM	AL	21.07.22
3	For Coordination	LM	AL	15.07.22
2	65% For coordination	LM	AL	04.07.22
1	65% DD	LM	AL	20.05.22

Not for Construction

Project
ST IGNATIUS RIVERVIEW S2
 LANE COVE NSW
 FOR TENDER



Drawing No. 401 Drawing Name SOFTWORKS 1



Job No. 19-655 Issue 8 Scale 1:50 A1

Sydney, Suite 76, Jones Bay Wharf, 26-32 Pirrama Road, Pyrmont NSW 2009
 E: sydney@arcadia.com.au
 T: 02 8571 2900



Copyright remains the property of Arcadia Design Group Pty Ltd. Use only figured dimensions. Any other required dimensions are to be referred to and supplied by the landscape architect. All discrepancies to be referred to the project manager and Arcadia Design Group Pty Ltd prior to construction. Ensure compliance with the Building Code of Australia and all relevant Australian Standards and Authority requirements.

- SOFTWORKS LEGEND**
- EXISTING TREES TO BE RETAINED
Refer Landscape Specification
 - EXISTING TREES TO BE REMOVED
Refer Landscape Specification
 - ANGOPHORA COSTATA
Refer Landscape Specification
 - BANKSIA INTEGRIFOLIA
Refer Landscape Specification
 - CERATOPETALUM GUMMIFERUM
Refer Landscape Specification
 - EUCALYPTUS HAEMASTOMA
Refer Landscape Specification
 - FICUS RUBIGINOSA
Refer Landscape Specification
 - LOPHOSTEMON CONFERTUS
Refer Landscape Specification
 - SHRUB AND ACCENT PLANTING
Refer Landscape Specification
 - GROUNDCOVER PLANTING
Refer Landscape Specification
 - MATRIX 1
Refer Landscape Specification
 - MATRIX 2
Refer Landscape Specification

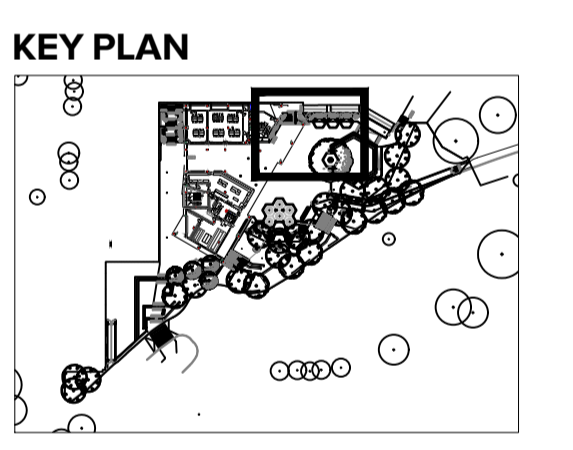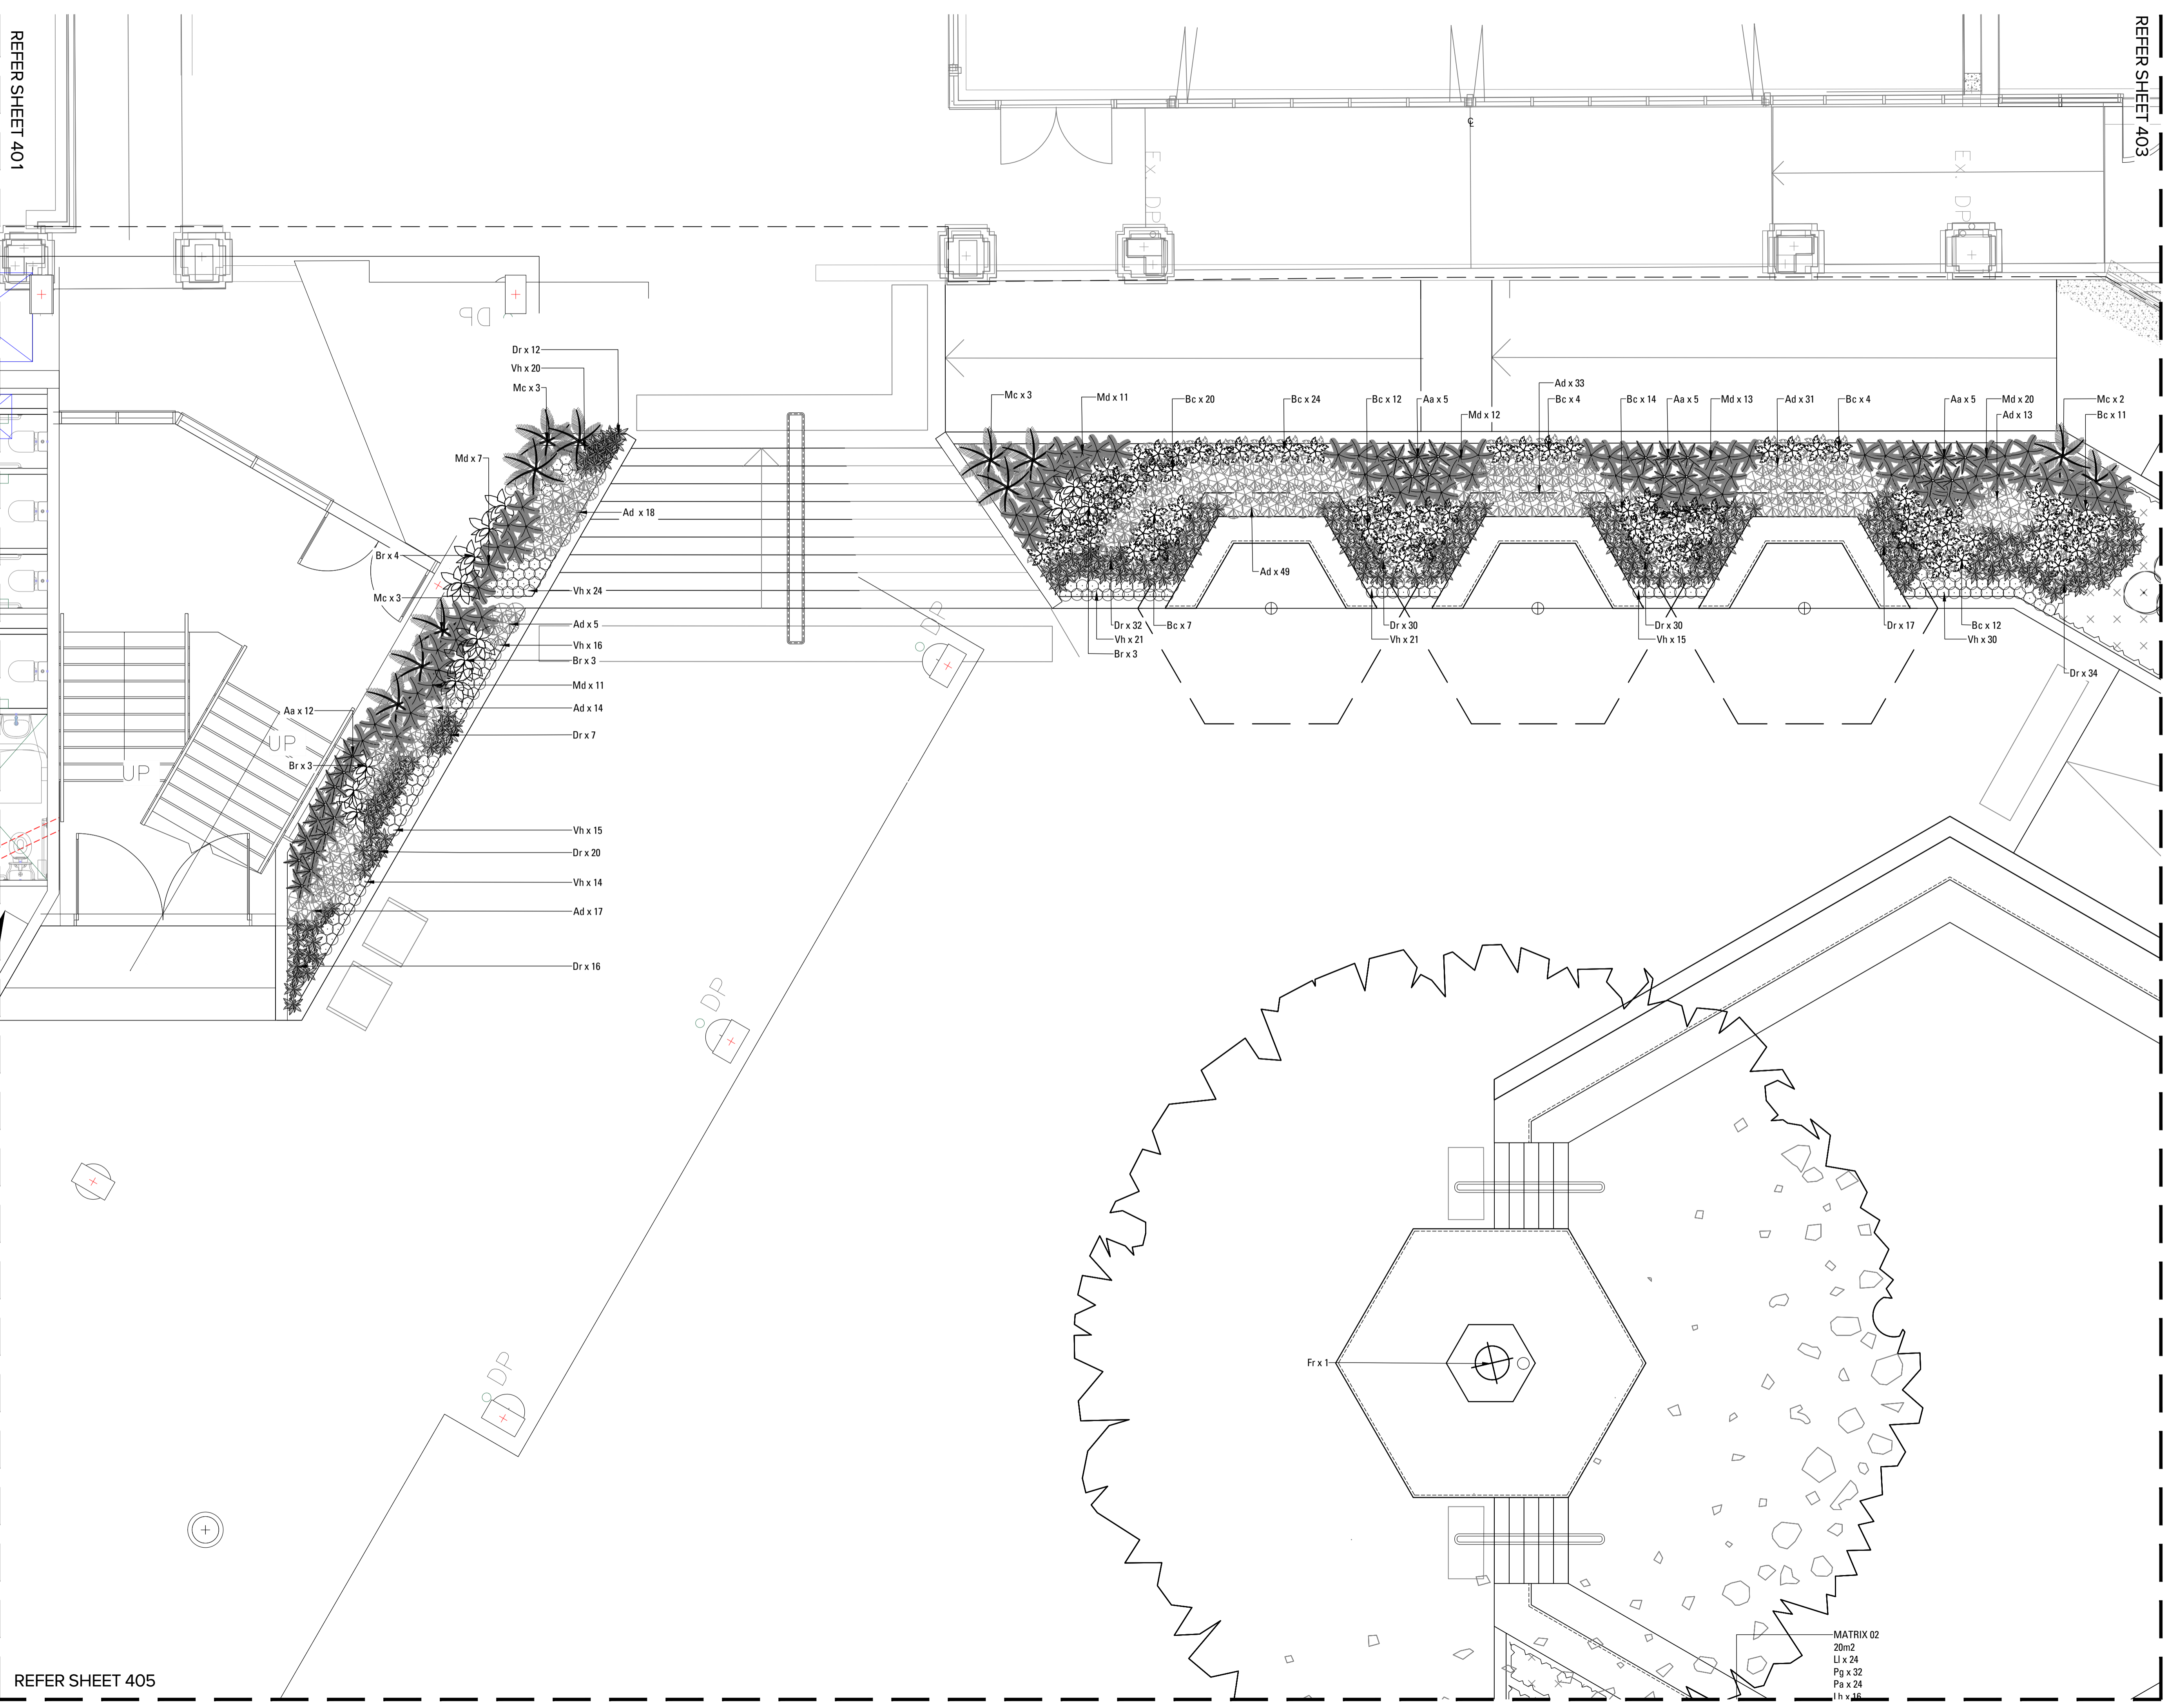

Issue	Revision	Description	Drawn	Check	Date
8		FOR TENDER	CL	AL	14.09.22
7		FOR TENDER	CL	AL	09.09.22
6		FOR TENDER	LM	AL	15.08.22
5		For Coordination	LM	AL	25.07.22
4		For Coordination	LM	AL	21.07.22
3		For Coordination	LM	AL	15.07.22
2		65% For coordination	LM	AL	04.07.22
1		65% DD	LM	AL	20.05.22

Not for Construction

Project
ST IGNATIUS RIVERVIEW S2
 LANE COVE NSW
 FOR TENDER

Client


Drawing No. 402 Drawing Name SOFTWORKS 2

Job No. 19-655 Issue 8 Scale 1:50 A1

Sydney, Suite 76, Jones Bay Wharf, 26-32 Pyrama Road, Pyrmont NSW 2009
 E:sydney@arcadiad.com.au
 T:02 8571 2900




MATRIX 02
 20m2
 Lj x 24
 Pg x 32
 Pa x 24
 1h x 46

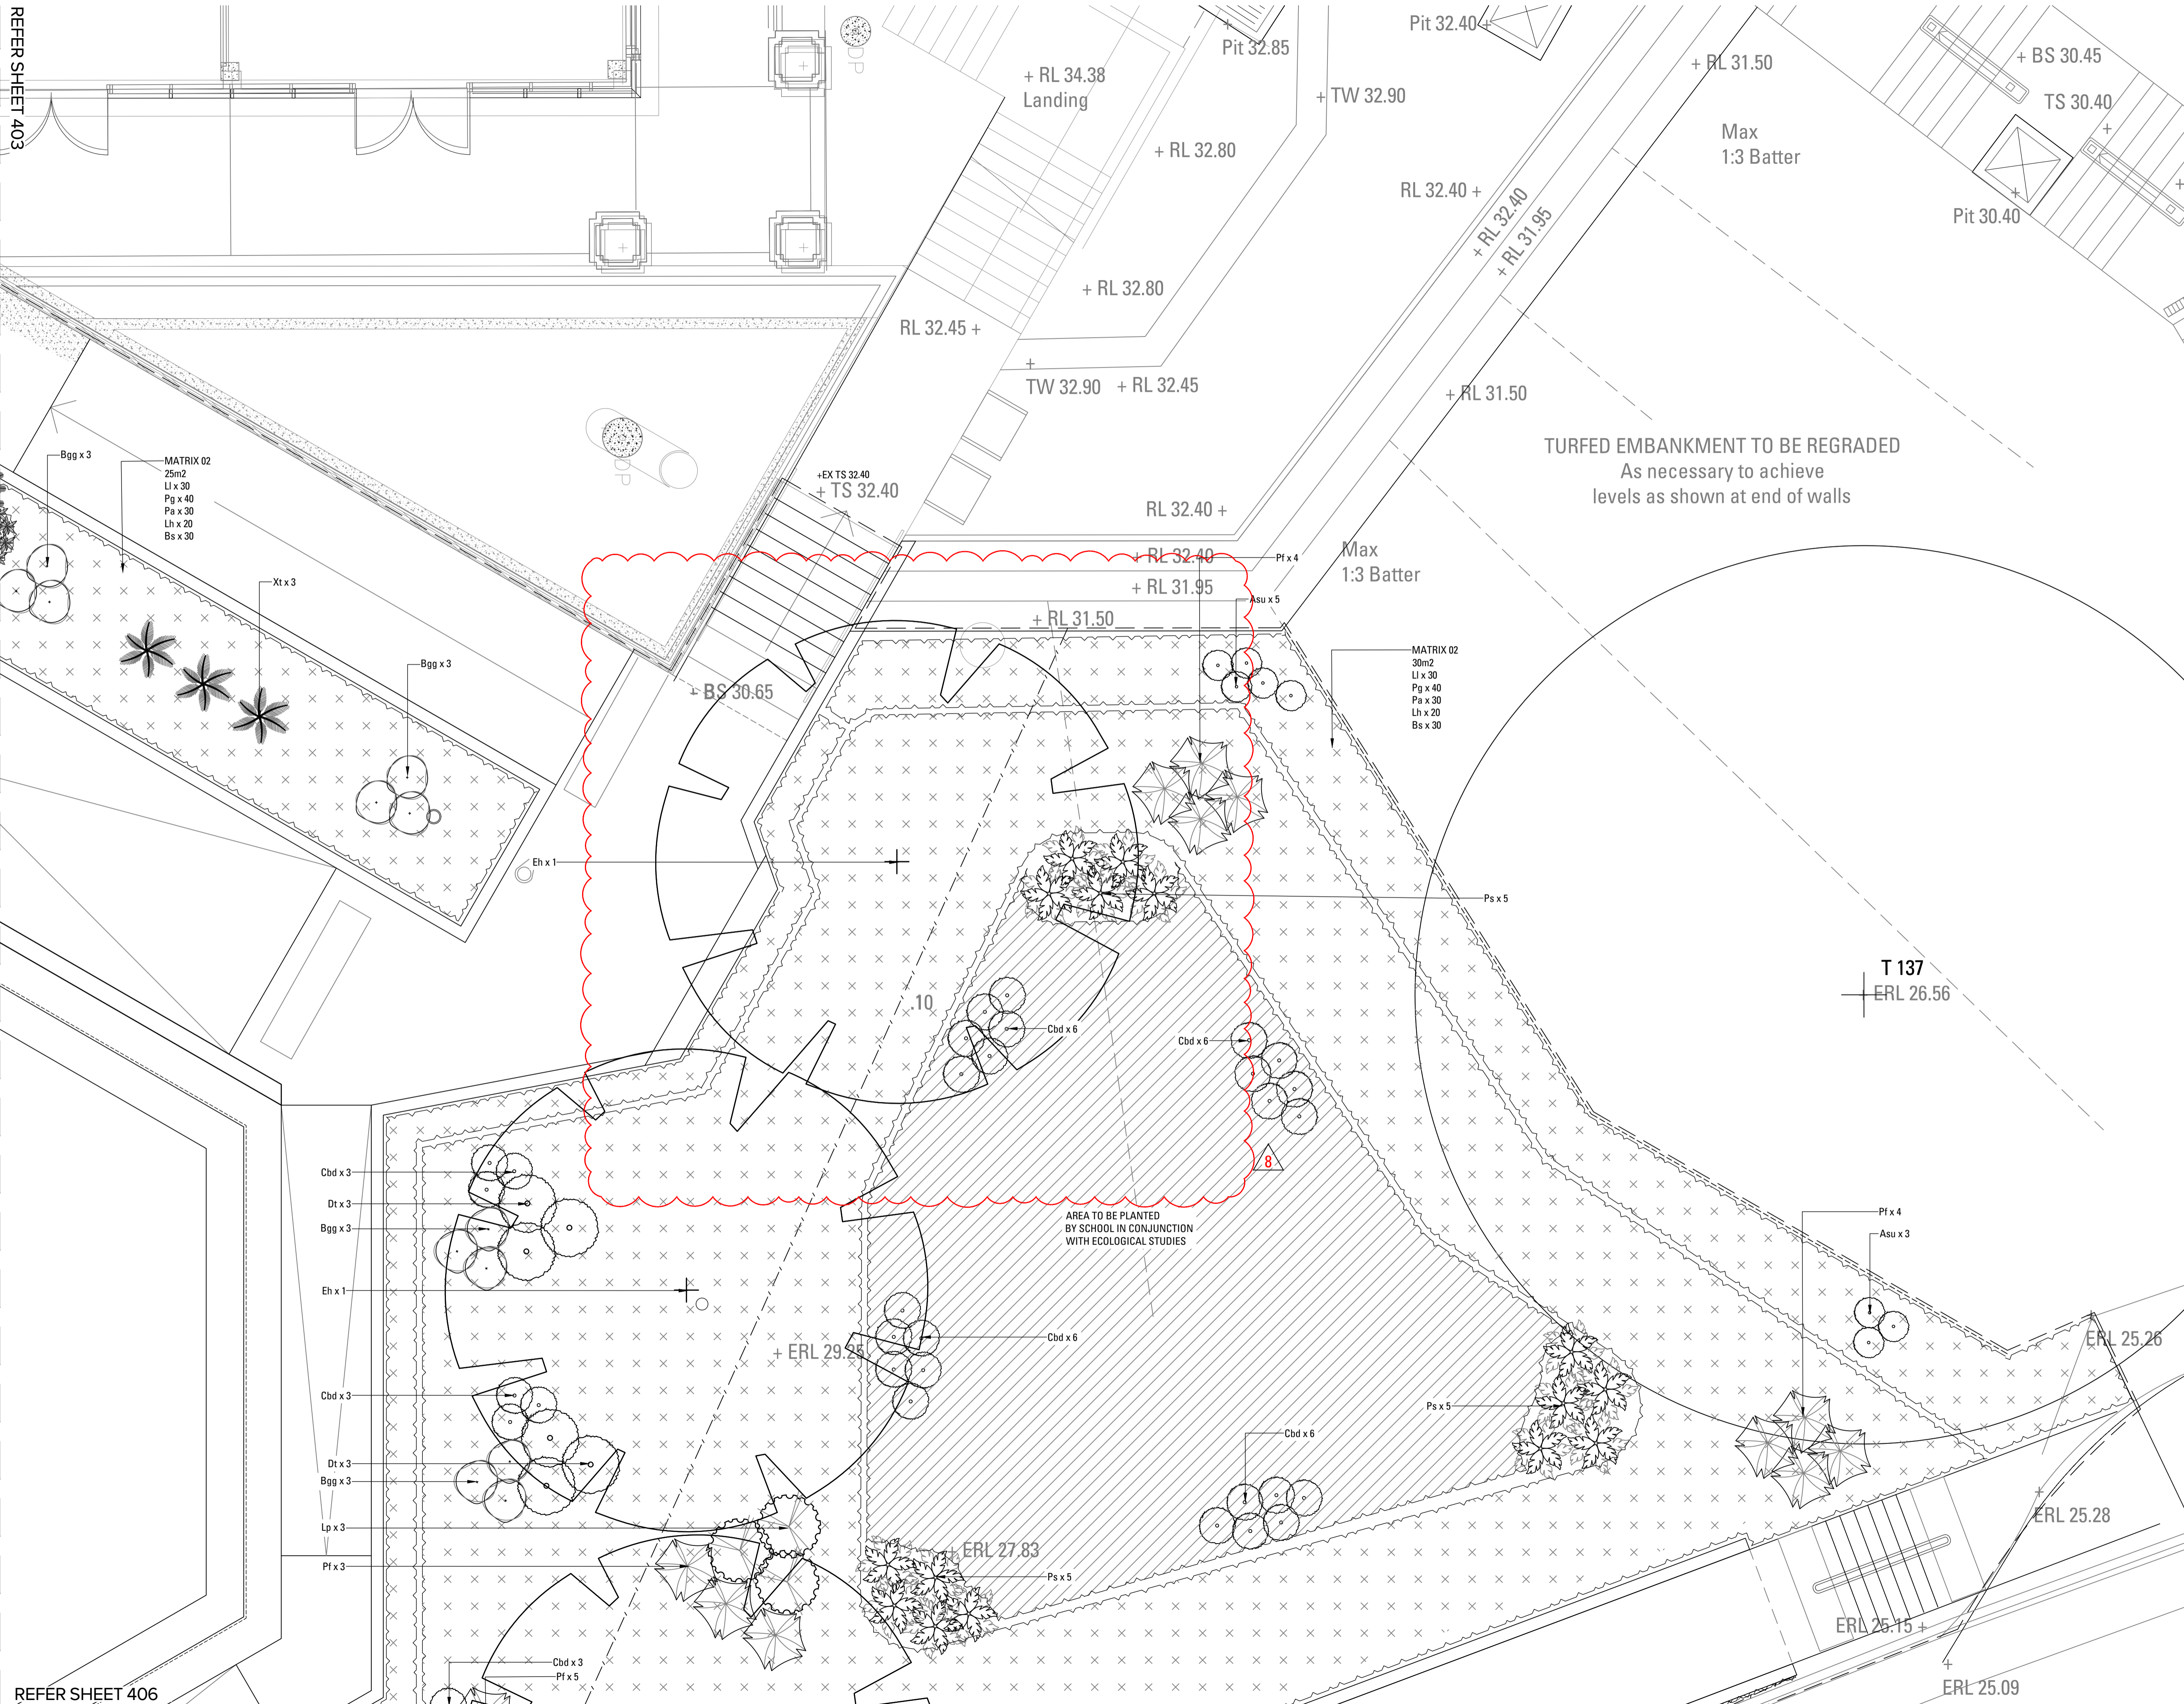

Copyright remains the property of Arcadia Design Group Pty Ltd. Use only figured dimensions. Any other required dimensions are to be referred to and supplied by the landscape architect. All discrepancies to be referred to the project manager and Arcadia Design Group Pty Ltd prior to construction. Ensure compliance with the Building Code of Australia and all relevant Australian Standards and Authority requirements.

- SOFTWARES LEGEND**
- EXISTING TREES TO BE RETAINED
Refer Landscape Specification
 - EXISTING TREES TO BE REMOVED
Refer Landscape Specification
 - ANGOPHORA COSTATA
Refer Landscape Specification
 - BANKSIA INTEGRIFOLIA
Refer Landscape Specification
 - CERATOPETALUM GUMMIFERUM
Refer Landscape Specification
 - EUCALYPTUS HAEMASTOMA
Refer Landscape Specification
 - FICUS RUBIGINOSA
Refer Landscape Specification
 - LOPHOSTEMON CONFERTUS
Refer Landscape Specification
 - SHRUB AND ACCENT PLANTING
Refer Landscape Specification
 - GROUNDCOVER PLANTING
Refer Landscape Specification
 - MATRIX 1
Refer Landscape Specification
 - MATRIX 2
Refer Landscape Specification

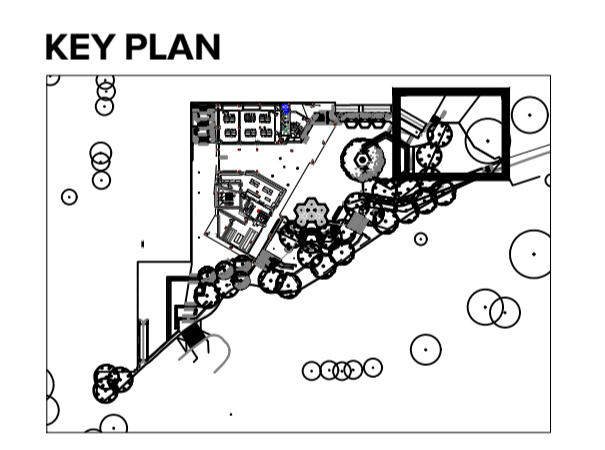

Issue	Revision Description	Drawn	Check	Date
8	FOR TENDER	CL	AL	14.09.22
7	FOR TENDER	CL	AL	09.09.22
6	FOR TENDER	LM	AL	15.08.22
5	For Coordination	LM	AL	25.07.22
4	For Coordination	LM	AL	21.07.22
3	For Coordination	LM	AL	15.07.22
2	65% For coordination	LM	AL	04.07.22
1	65% DO	LM	AL	20.05.22

Not for Construction

Project
ST IGNATIUS RIVERVIEW S2
LANE COVE NSW
 FOR TENDER



Drawing No. 403 Drawing Name SOFTWARES 3


Job No. 19-655 Issue 8 Scale 1:50 A1

Sydney, Suite 76, Jones Bay Wharf, 26-32 Pirrama Road, Pyrmont NSW 2009
 E:sydney@arcadia.com.au T:02 8571 2900




Copyright remains the property of Arcadia Design Group Pty Ltd. Use only figured dimensions. Any other required dimensions are to be referred to and supplied by the landscape architect. All discrepancies to be referred to the project manager and Arcadia Design Group Pty Ltd prior to construction. Ensure compliance with the Building Code of Australia and all relevant Australian Standards and Authority requirements.

- SOFTWORKS LEGEND**
- EXISTING TREES TO BE RETAINED
Refer Landscape Specification
 - EXISTING TREES TO BE REMOVED
Refer Landscape Specification
 - ANGOPHORA COSTATA
Refer Landscape Specification
 - BANKSIA INTEGRIFOLIA
Refer Landscape Specification
 - CERATOPETALUM GUMMIFERUM
Refer Landscape Specification
 - EUCALYPTUS HAEMASTOMA
Refer Landscape Specification
 - FICUS RUBIGINOSA
Refer Landscape Specification
 - LOPHOSTEMON CONFERTUS
Refer Landscape Specification
 - SHRUB AND ACCENT PLANTING
Refer Landscape Specification
 - GROUND COVER PLANTING
Refer Landscape Specification
 - MATRIX 1
Refer Landscape Specification
 - MATRIX 2
Refer Landscape Specification

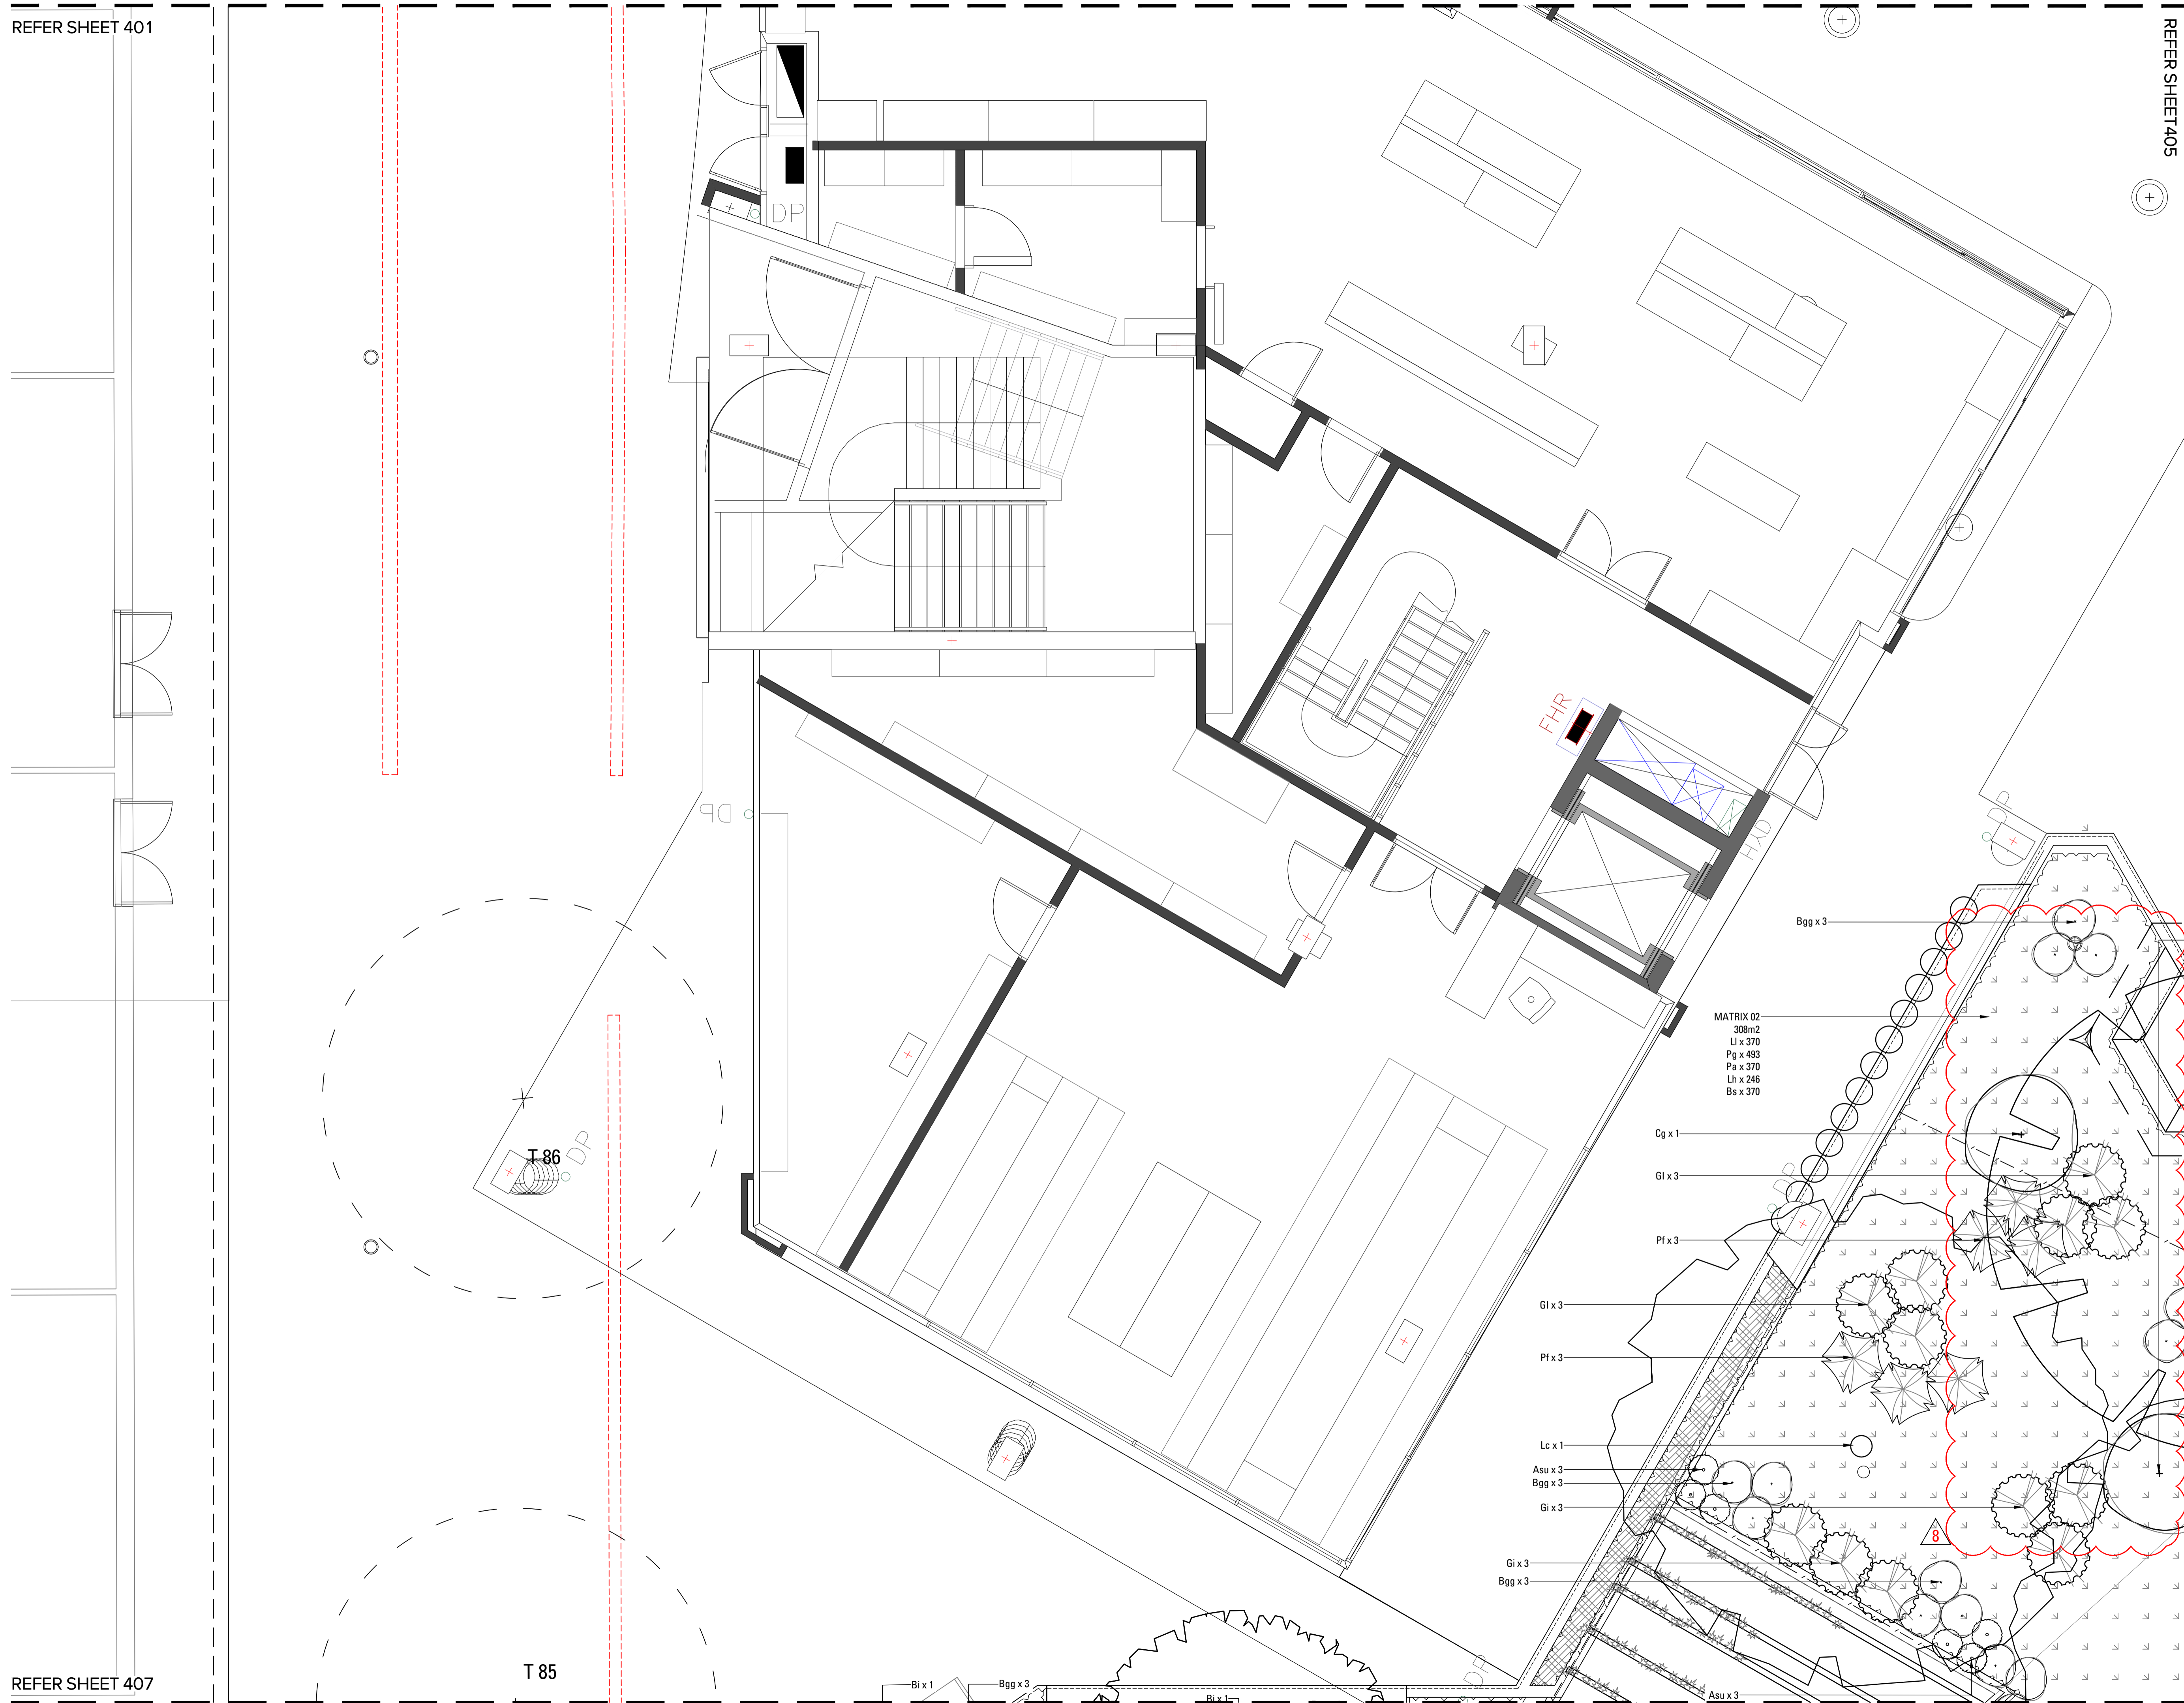

MATRIX 02
308m2
Ll x 370
Pg x 493
Pa x 370
Lh x 246
Bs x 370

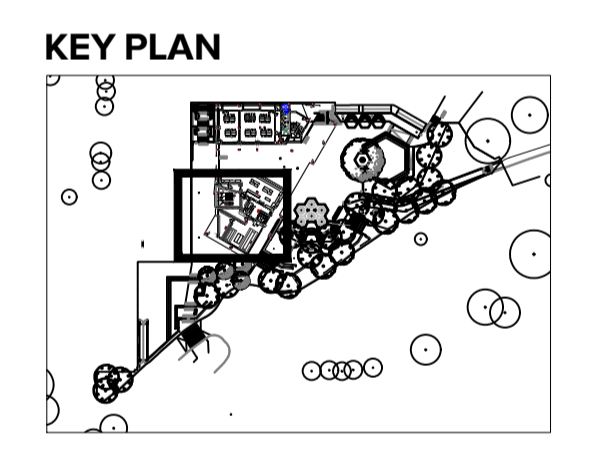

Issue	Revision Description	Drawn	Check	Date
8	FOR TENDER	CL	AL	14.09.22
7	FOR TENDER	CL	AL	09.09.22
6	FOR TENDER	LM	AL	15.08.22
5	For Coordination	LM	AL	25.07.22
4	For Coordination	LM	AL	21.07.22
3	For Coordination	LM	AL	15.07.22
2	65% For coordination	LM	AL	04.07.22
1	65% DD	LM	AL	20.05.22

Not for Construction

Project
ST IGNATIUS RIVERVIEW S2
LANE COVE NSW
FOR TENDER

Client
 Saint Ignatius College RIVERVIEW

Drawing No. 404 Drawing Name SOFTWORKS 4


Job No. 19-655 Issue 8 Scale 1:50 A1

Sydney, Suite 76, Jones Bay Wharf, 26-32 Pirrama Road, Pyrmont NSW 2009
E: sydney@arcadiata.com.au
T: 02 8571 2900



Copyright remains the property of Arcadia Design Group Pty Ltd. Use only figured dimensions. Any other required dimensions are to be referred to and supplied by the landscape architect. All discrepancies to be referred to the project manager and Arcadia Design Group Pty Ltd prior to construction. Ensure compliance with the Building Code of Australia and all relevant Australian Standards and Authority requirements.

- SOFTWARES LEGEND**
- EXISTING TREES TO BE RETAINED
Refer Landscape Specification
 - EXISTING TREES TO BE REMOVED
Refer Landscape Specification
 - ANGOPHORA COSTATA
Refer Landscape Specification
 - BANKSIA INTEGRIFOLIA
Refer Landscape Specification
 - CERATOPETALUM GUMMIFERUM
Refer Landscape Specification
 - EUCALYPTUS HAEMASTOMA
Refer Landscape Specification
 - FICUS RUBIGINOSA
Refer Landscape Specification
 - LOPHOSTEMON CONFERTUS
Refer Landscape Specification
 - SHRUB AND ACCENT PLANTING
Refer Landscape Specification
 - GROUNDCOVER PLANTING
Refer Landscape Specification
 - MATRIX 1
Refer Landscape Specification
 - MATRIX 2
Refer Landscape Specification

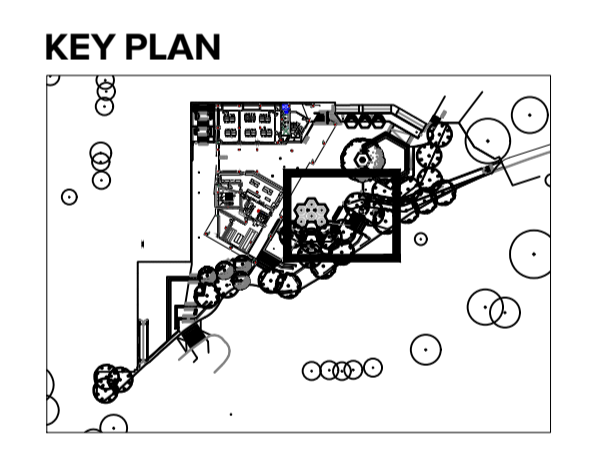

Issue	Revision	Description	Drawn	Check	Date
8	FOR TENDER	CL	AL	14.09.22	
7	FOR TENDER	CL	AL	09.09.22	
6	FOR TENDER	LM	AL	15.08.22	
5	For Coordination	LM	AL	25.07.22	
4	For Coordination	LM	AL	21.07.22	
3	For Coordination	LM	AL	15.07.22	
2	65% For coordination	LM	AL	04.07.22	
1	65% DO	LM	AL	20.05.22	

Not for Construction


Project
ST IGNATIUS RIVERVIEW S2
 LANE COVE NSW
 FOR TENDER

Client
 Saint Ignatius College RIVERVIEW


Drawing No. 405 Drawing Name SOFTWARES 5

Job No. 19-655 Issue 8 Scale 1:50 A1

Sydney, Suite 76, Jones Bay Wharf, 26-32 Pirrama Road, Pyrmont NSW 2009
 E: sydney@arcadia.com.au T: 02 8571 2900

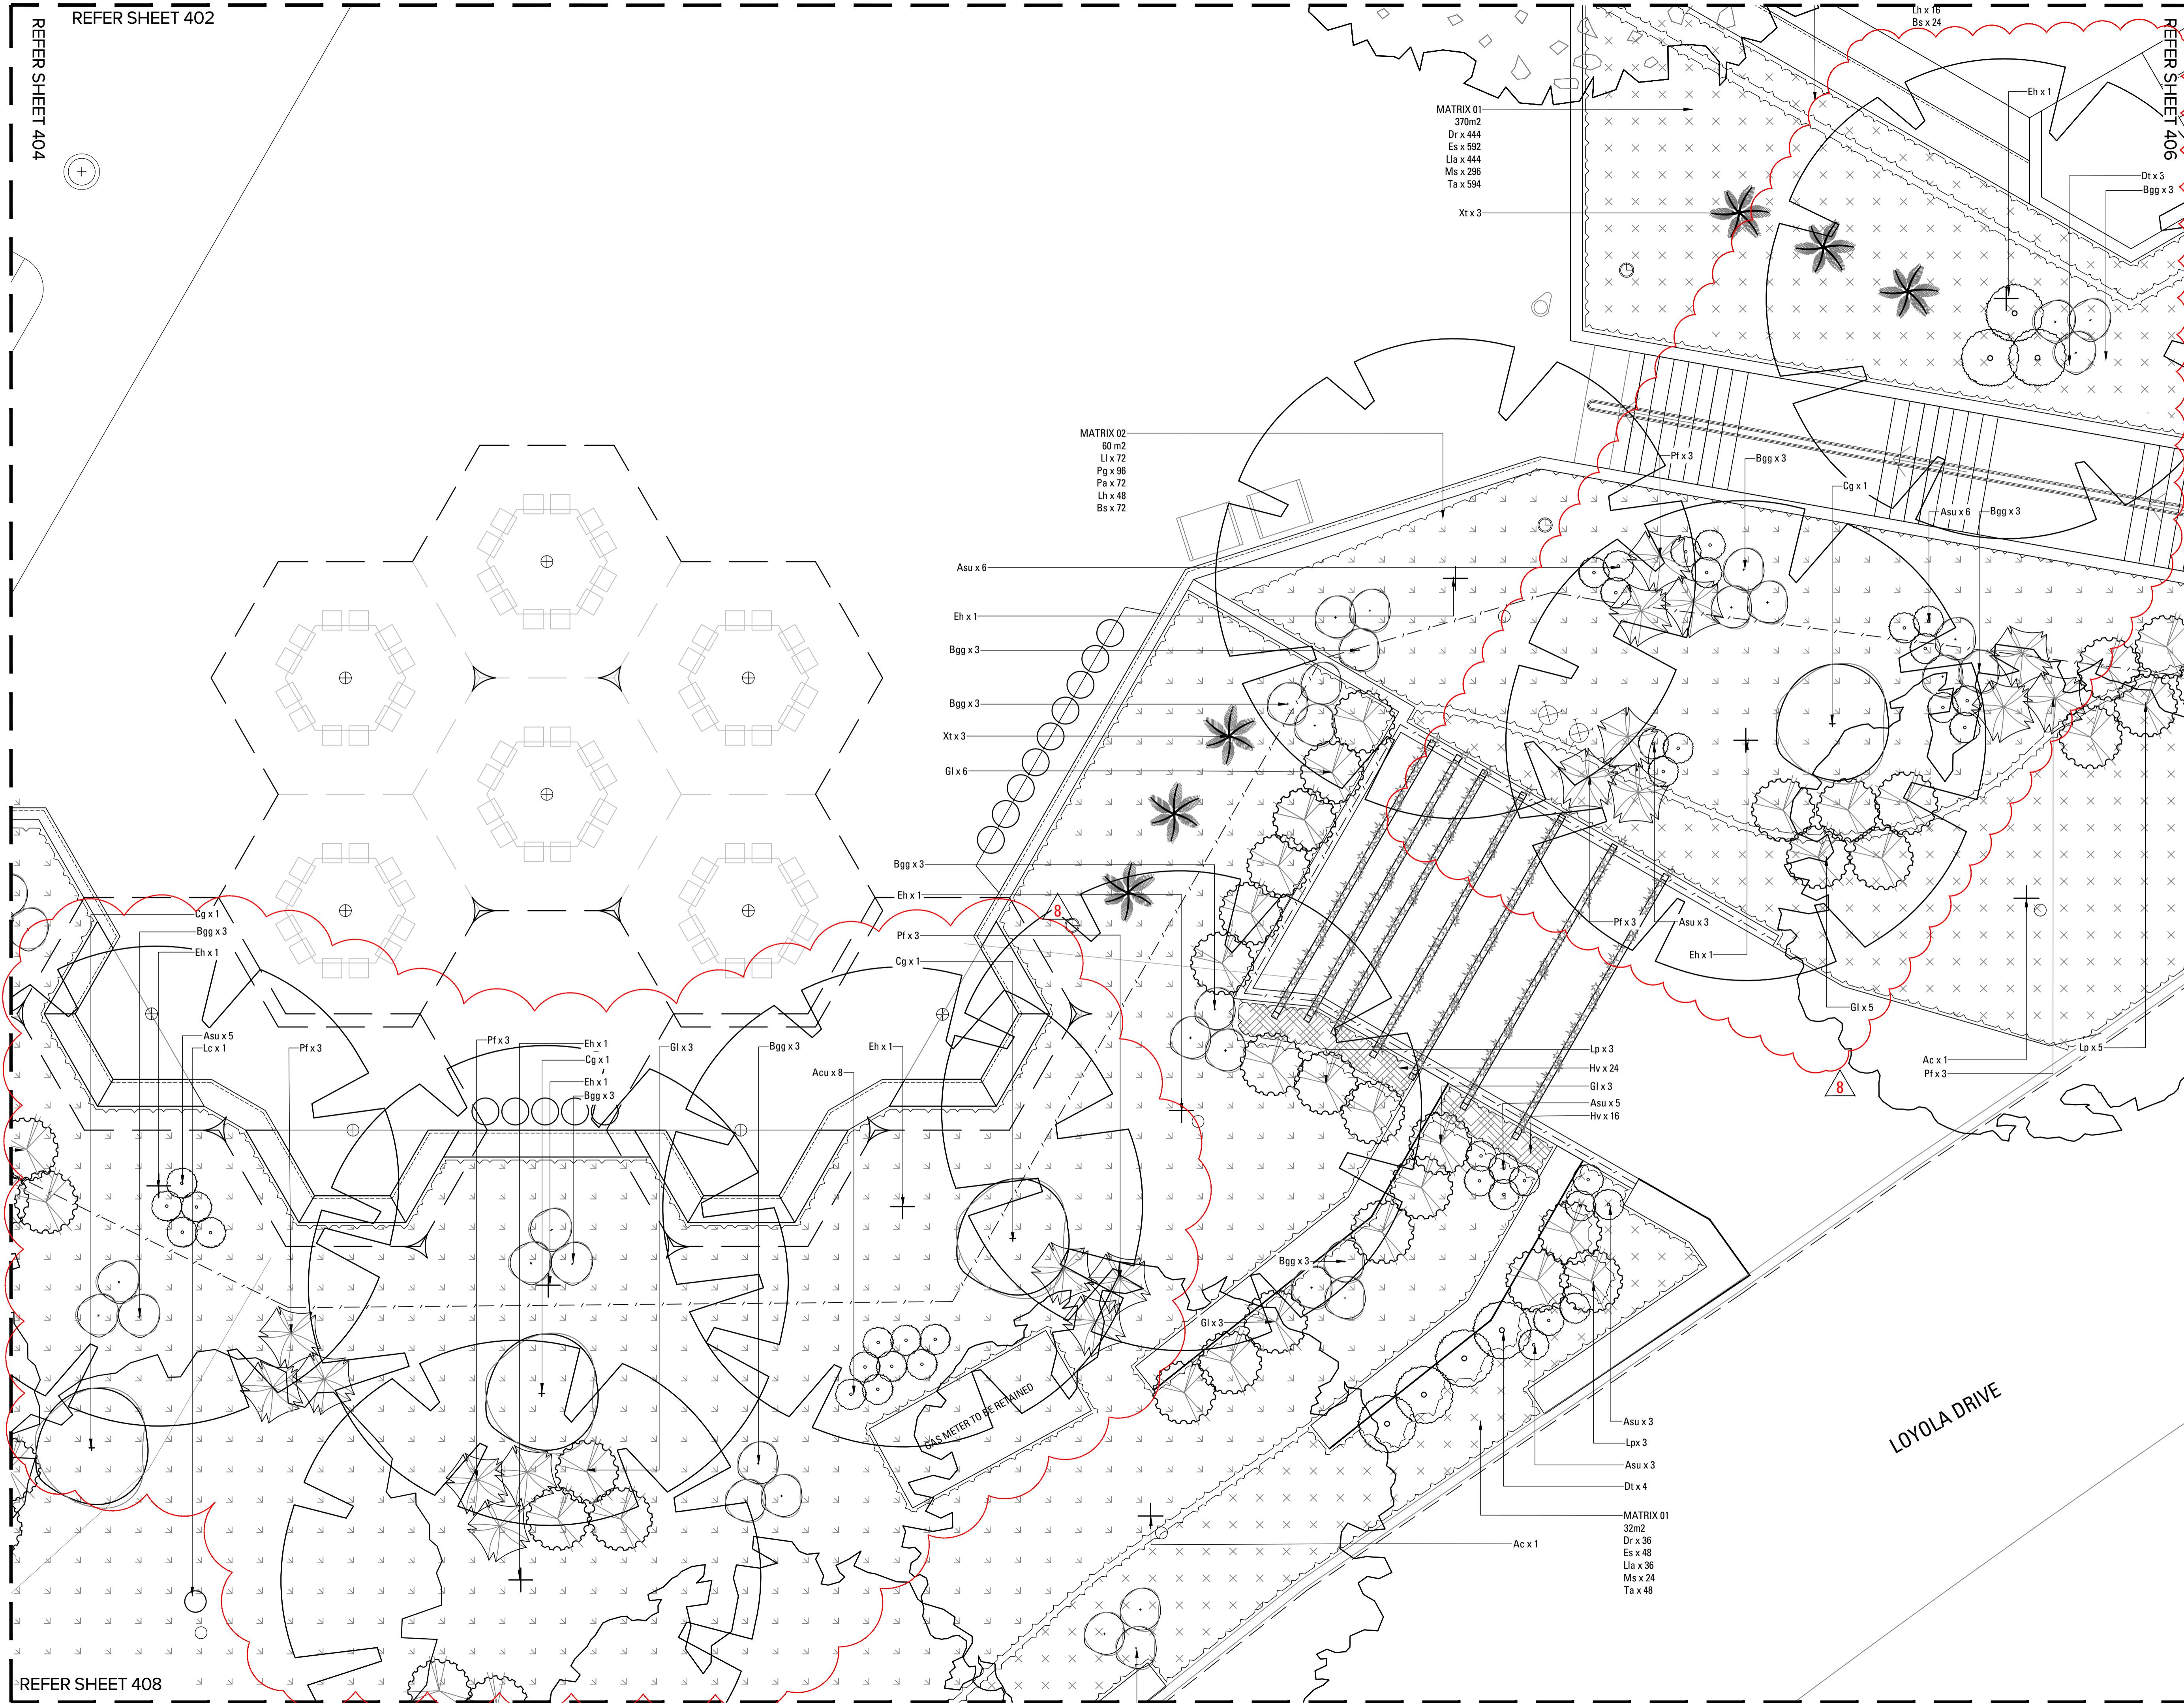



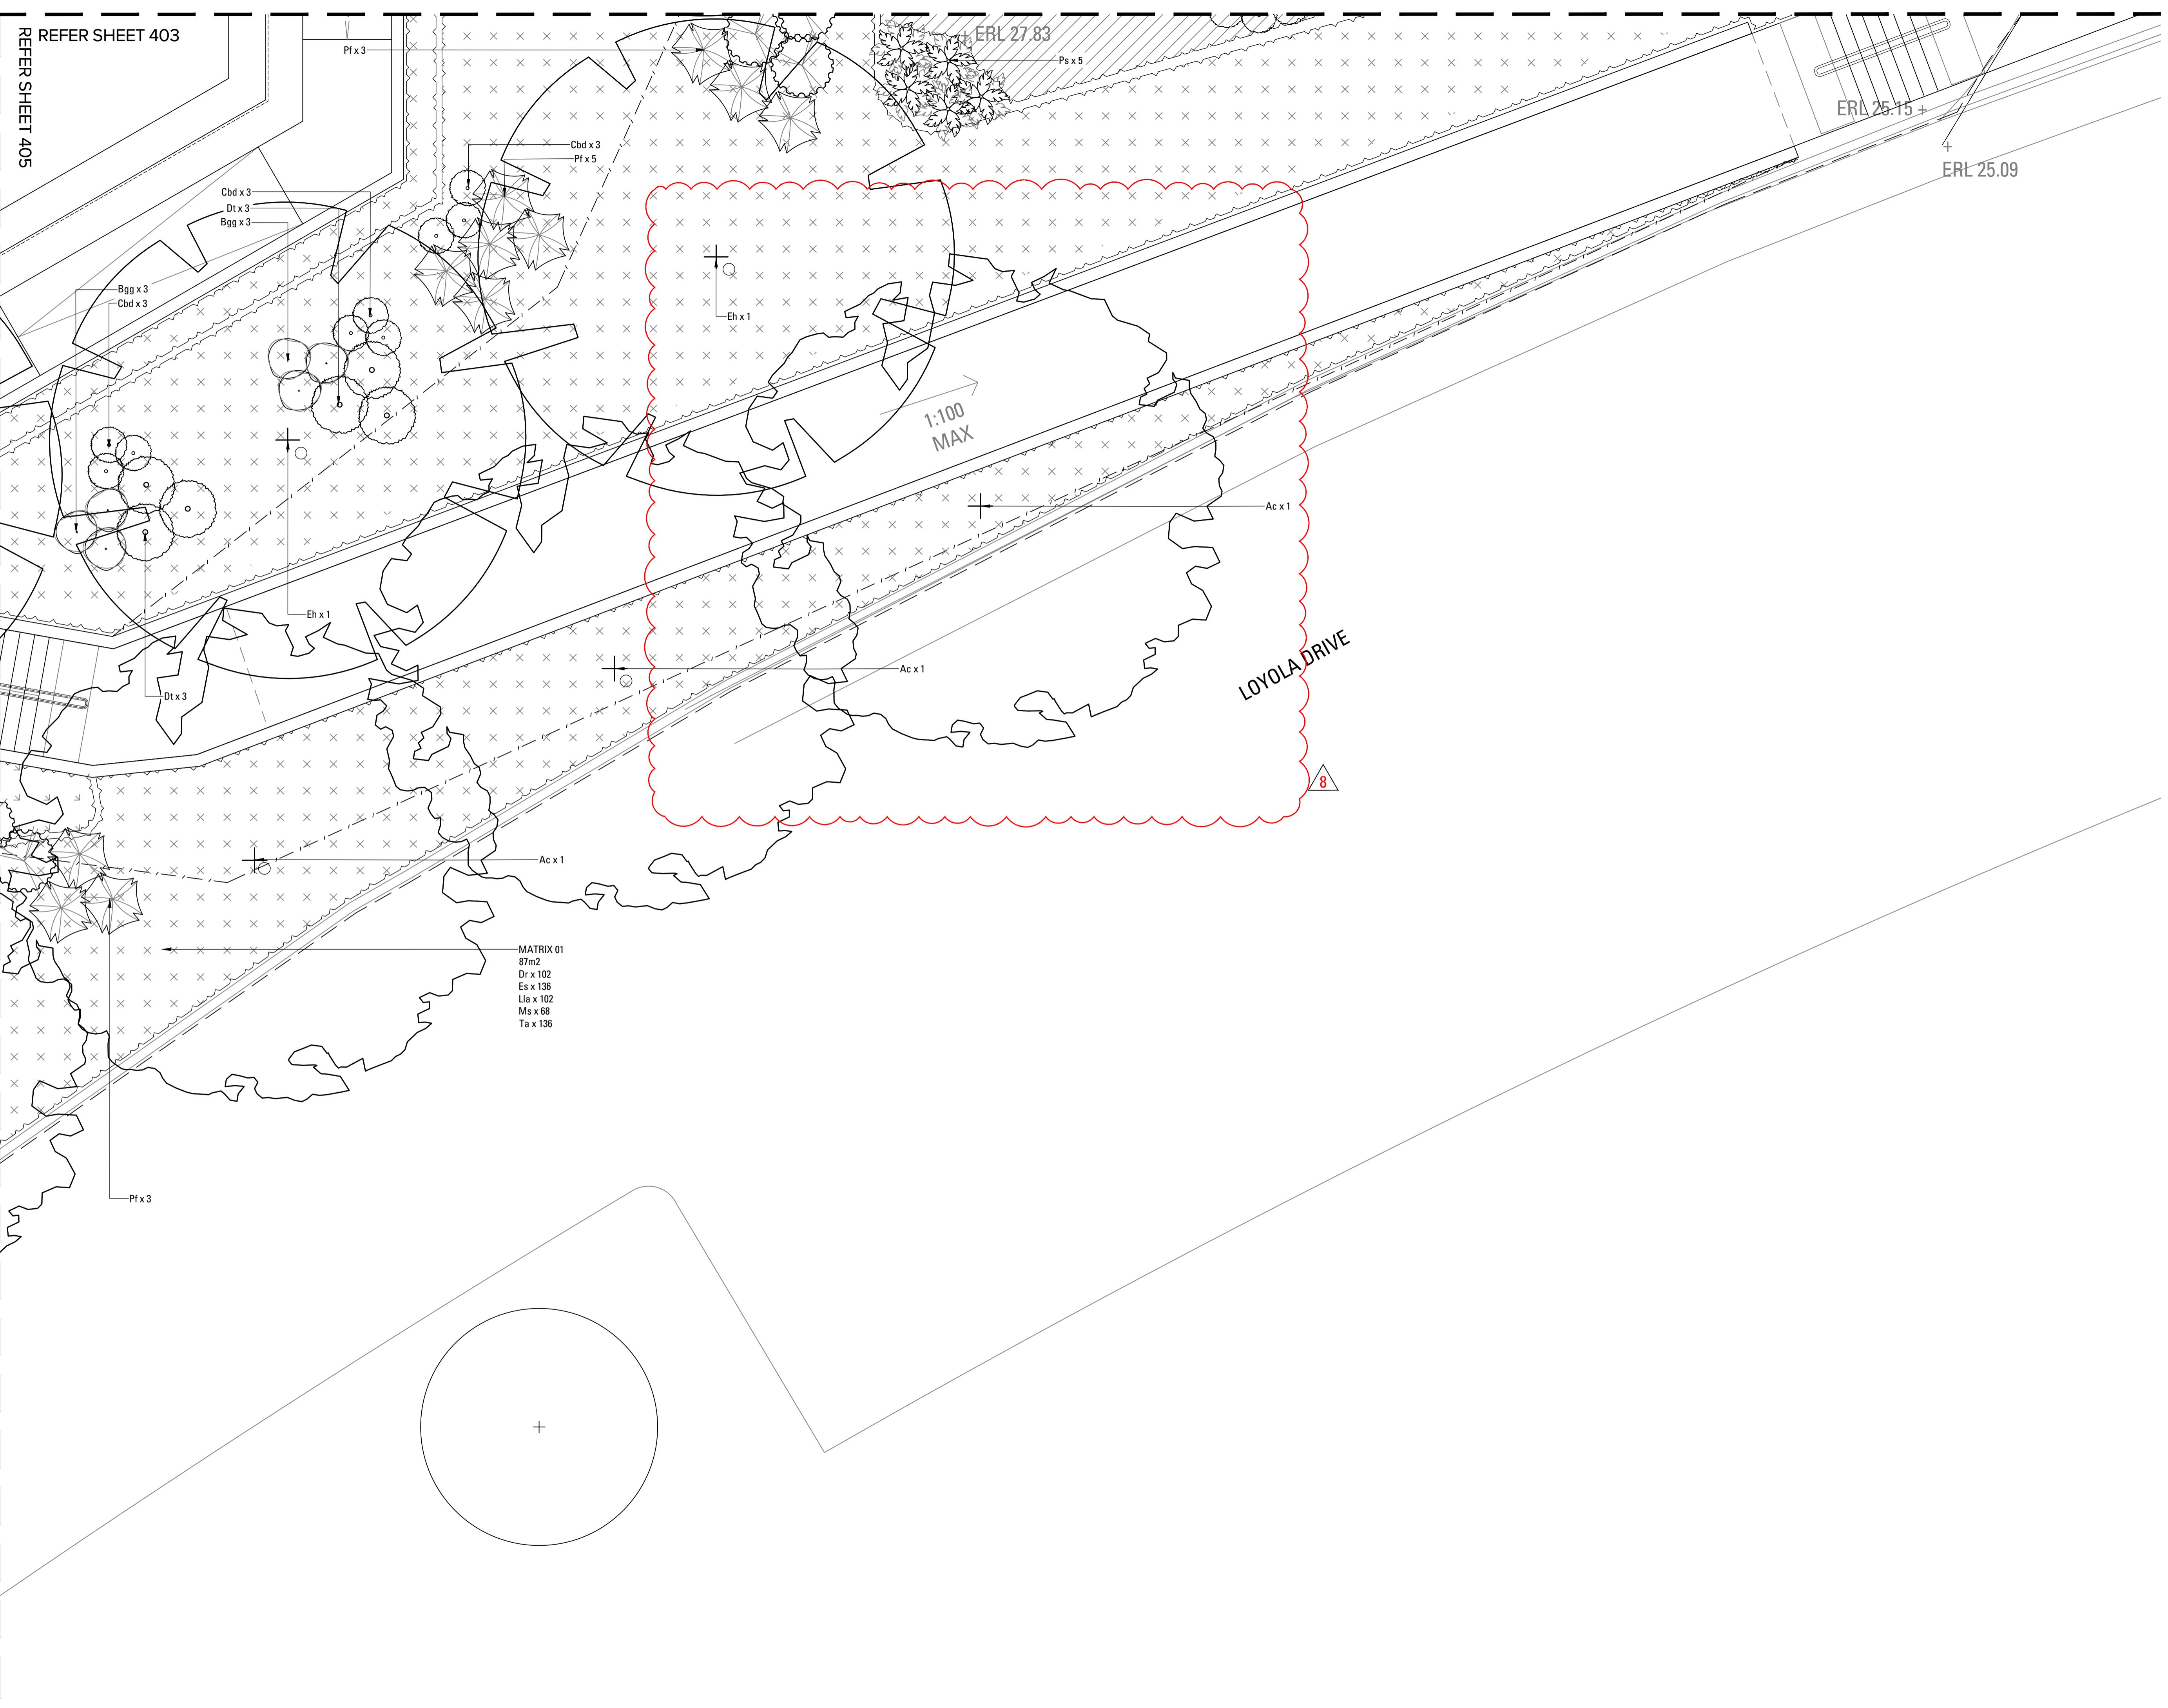










REFER SHEET 403
REFER SHEET 405

 

MATRIX 01
87m2
Dr x 102
Es x 136
Lia x 102
Ms x 68
Ta x 136

 Copyright remains the property of Arcadia Design Group Pty Ltd. Use only figured dimensions. Any other required dimensions are to be referred to and supplied by the landscape architect. All discrepancies to be referred to the project manager and Arcadia Design Group Pty Ltd prior to construction. Ensure compliance with the Building Code of Australia and all relevant Australian Standards and Authority requirements.

- SOFTWARES LEGEND**
-  EXISTING TREES TO BE RETAINED
Refer Landscape Specification
 -  EXISTING TREES TO BE REMOVED
Refer Landscape Specification
 -  ANGOPHORA COSTATA
Refer Landscape Specification
 -  BANKSIA INTEGRIFOLIA
Refer Landscape Specification
 -  CERATOPETALUM GUMMIFERUM
Refer Landscape Specification
 -  EUCALYPTUS HAEMASTOMA
Refer Landscape Specification
 -  FICUS RUBIGINOSA
Refer Landscape Specification
 -  LOPHOSTEMON CONFERTUS
Refer Landscape Specification
 -  SHRUB AND ACCENT PLANTING
Refer Landscape Specification
 -  GROUNDCOVER PLANTING
Refer Landscape Specification
 -  MATRIX 1
Refer Landscape Specification
 -  MATRIX 2
Refer Landscape Specification

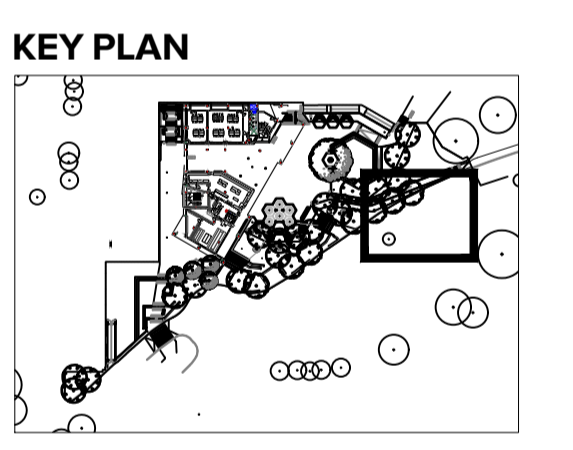

Issue	Revision Description	Drawn	Check	Date
8	FOR TENDER	CL	AL	14.09.22
7	FOR TENDER	CL	AL	09.09.22
6	FOR TENDER	LM	AL	15.08.22
5	For Coordination	LM	AL	25.07.22
4	For Coordination	LM	AL	21.07.22
3	For Coordination	LM	AL	15.07.22
2	65% For coordination	LM	AL	04.07.22
1	65% DD	LM	AL	20.05.22

Not for Construction

Project
ST IGNATIUS RIVERVIEW S2
LANE COVE NSW
FOR TENDER

Client



Drawing No. 406 Drawing Name SOFTWARES 6


 






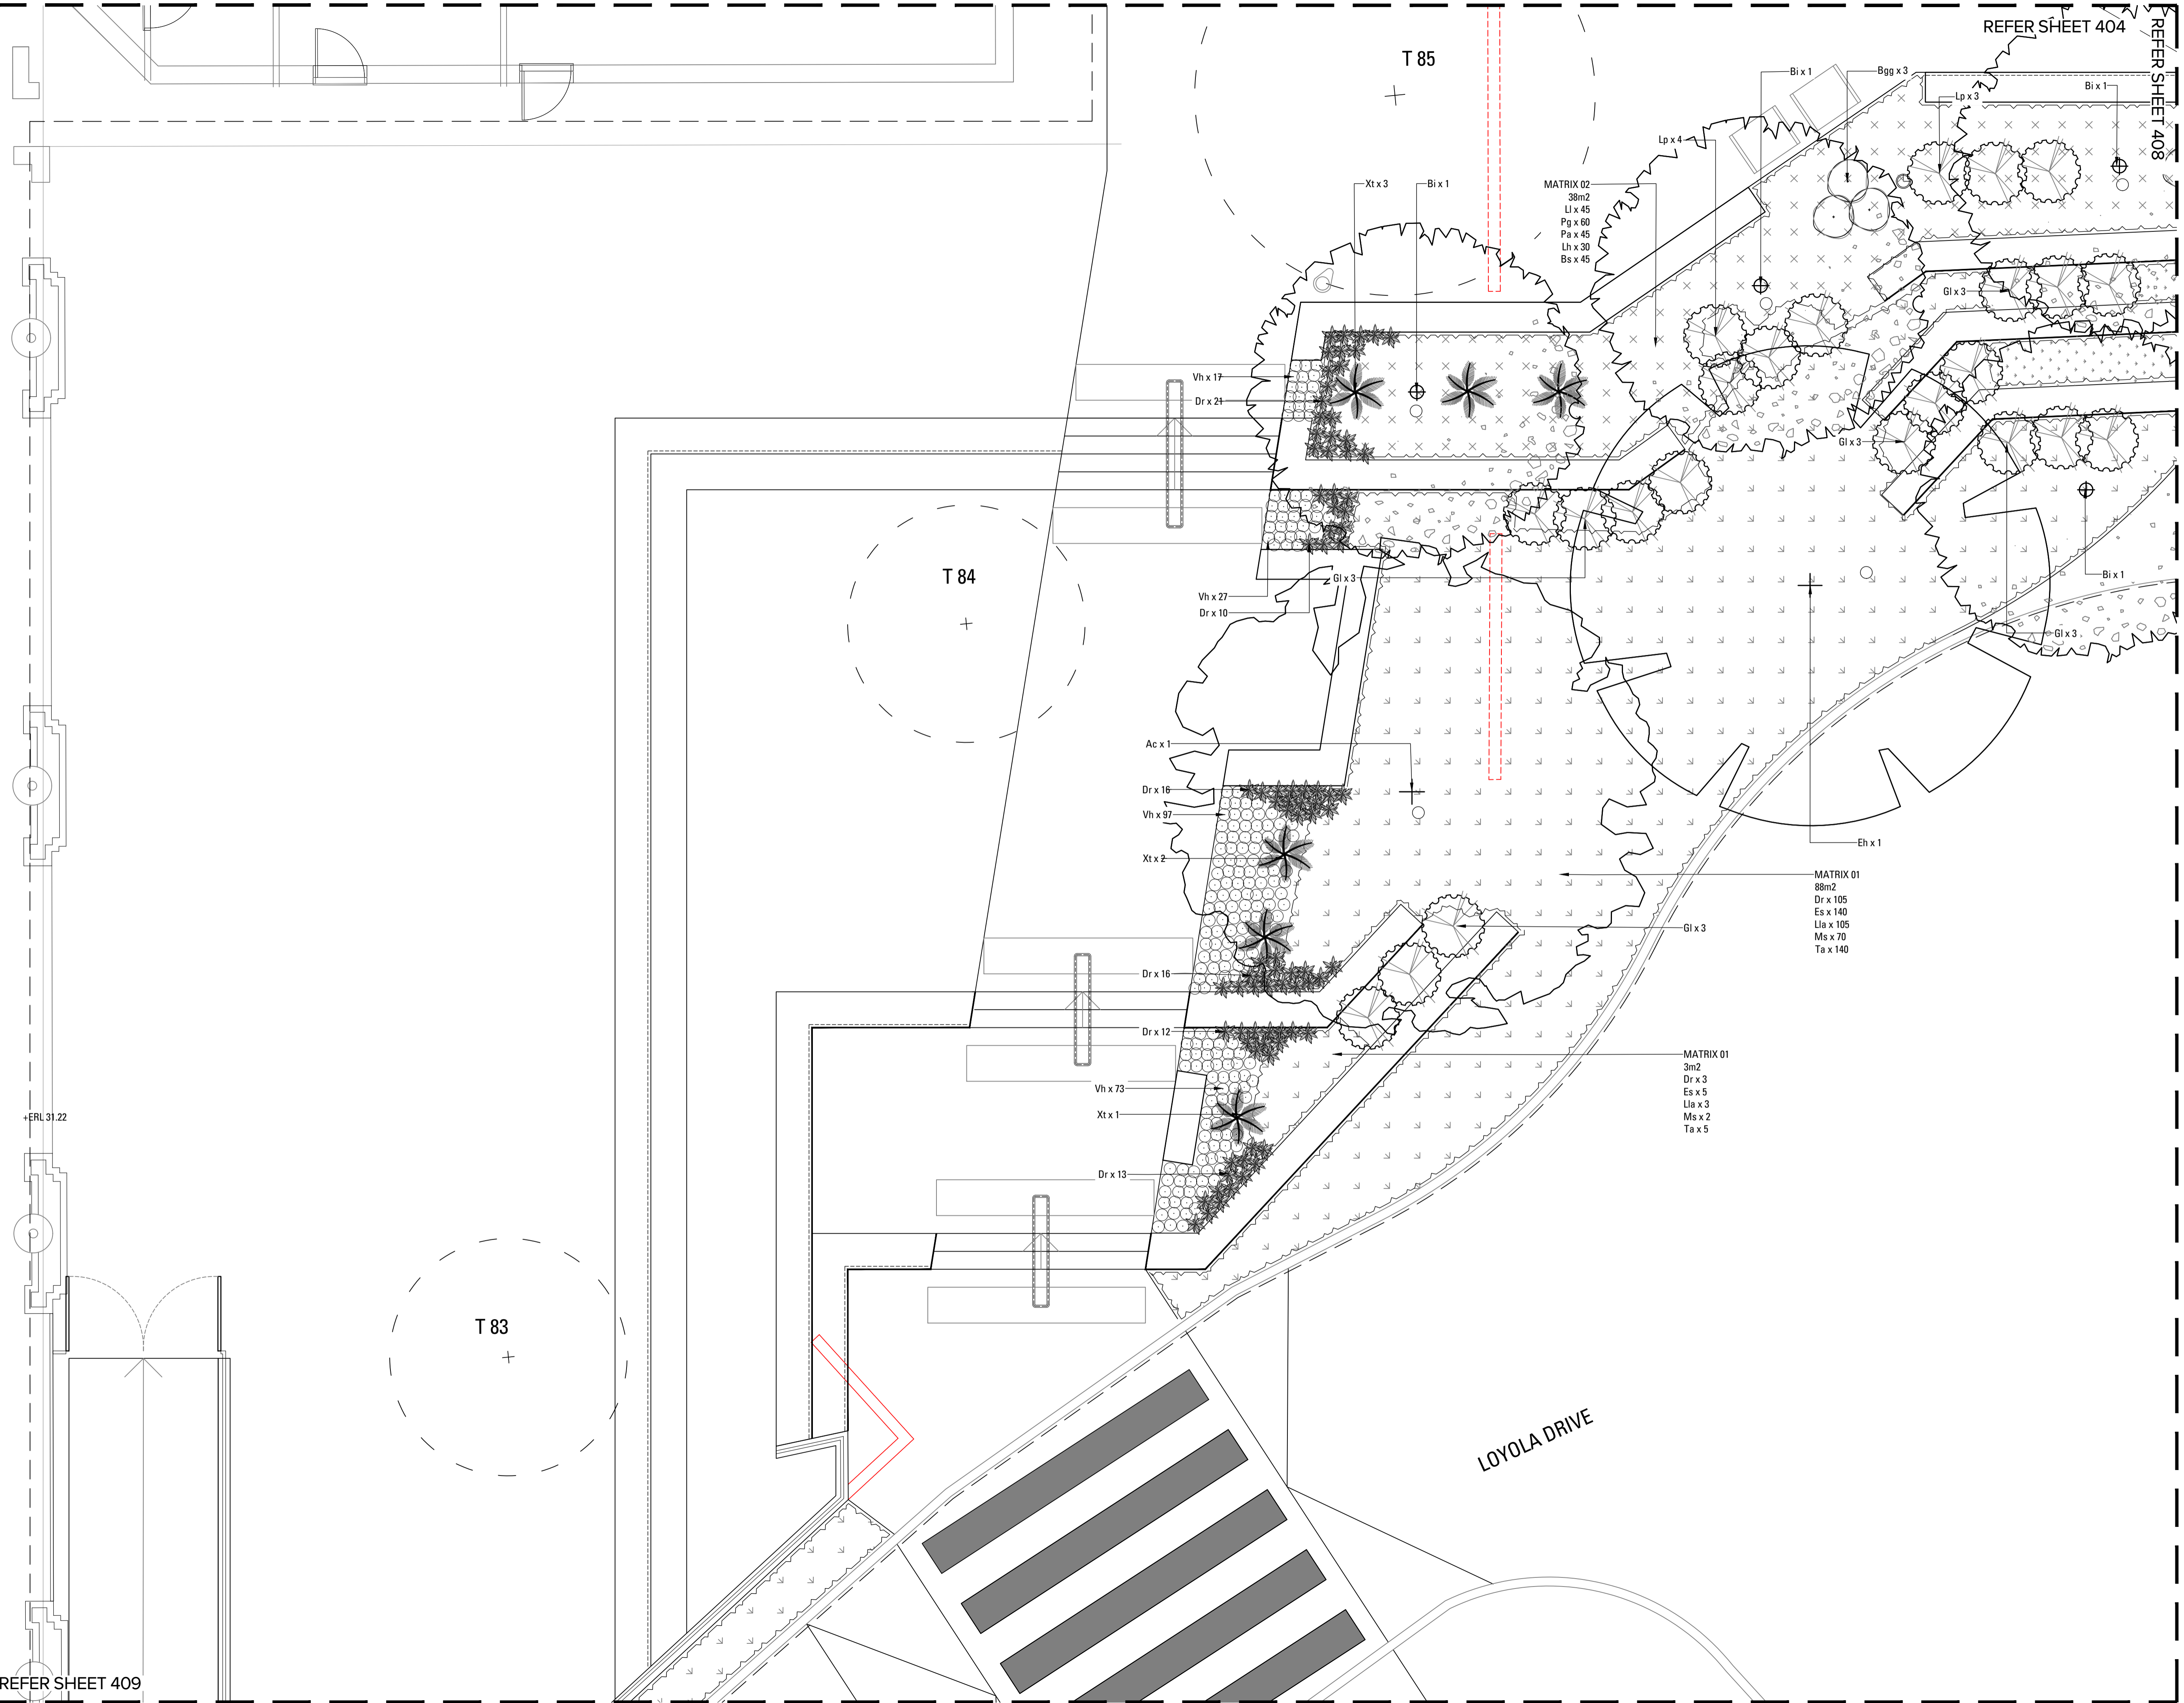


 
Job No. 19-655 Issue 8 Scale 1:50 A1

Sydney, Suite 76, Jones Bay Wharf, 26-32 Pirrama Road, Pyrmont NSW 2009
E sydney@arcadia.com.au
T 02 8571 2900


ARCADIA

Copyright remains the property of Arcadia Design Group Pty Ltd. Use only figured dimensions. Any other required dimensions are to be referred to and supplied by the landscape architect. All discrepancies to be referred to the project manager and Arcadia Design Group Pty Ltd prior to construction. Ensure compliance with the Building Code of Australia and all relevant Australian Standards and Authority requirements.



- SOFTWARES LEGEND**
-  EXISTING TREES TO BE RETAINED
Refer Landscape Specification
 -  EXISTING TREES TO BE REMOVED
Refer Landscape Specification
 -  ANGOPHORA COSTATA
Refer Landscape Specification
 -  BANKSIA INTEGRIFOLIA
Refer Landscape Specification
 -  CERATOPETALUM GUMMIFERUM
Refer Landscape Specification
 -  EUCALYPTUS HAEMASTOMA
Refer Landscape Specification
 -  FICUS RUBIGINOSA
Refer Landscape Specification
 -  LOPHOSTEMON CONFERTUS
Refer Landscape Specification
 -  SHRUB AND ACCENT PLANTING
Refer Landscape Specification
 -  GROUNDCOVER PLANTING
Refer Landscape Specification
 -  MATRIX 1
Refer Landscape Specification
 -  MATRIX 2
Refer Landscape Specification

KEY PLAN

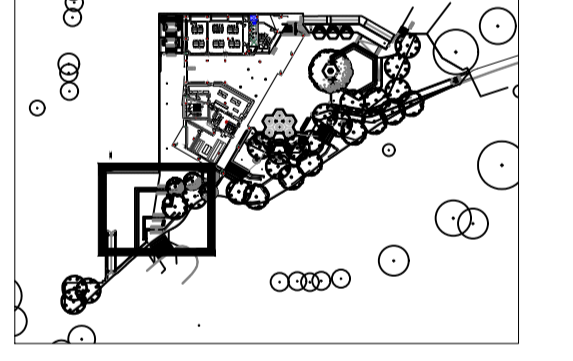

Issue	Revision Description	Drawn	Check	Date
8	FOR TENDER	CL	AL	14.09.22
7	FOR TENDER	CL	AL	09.09.22
6	FOR TENDER	LM	AL	15.08.22
5	For Coordination	LM	AL	25.07.22
4	For Coordination	LM	AL	21.07.22
3	For Coordination	LM	AL	15.07.22
2	65% For coordination	LM	AL	04.07.22
1	65% DD	LM	AL	20.05.22

Not for Construction

Project
ST IGNATIUS
RIVERVIEW S2
LANE COVE NSW
 FOR TENDER



Drawing No. **407** Drawing Name **SOFTWARES 7**


Job No. 19-655
 Issue 8
 Scale 1:50 A1

Sydney, Suite 76, Jones Bay
 Wharf, 26-32 Pirrama Road,
 Pyrmont NSW 2009
 E:sydney@arcadia.com.au
 T:02 8571 2900




+ERL 31.22

Copyright remains the property of Arcadia Design Group Pty Ltd. Use only figured dimensions. Any other required dimensions are to be referred to and supplied by the landscape architect. All discrepancies to be referred to the project manager and Arcadia Design Group Pty Ltd prior to construction. Ensure compliance with the Building Code of Australia and all relevant Australian Standards and Authority requirements.

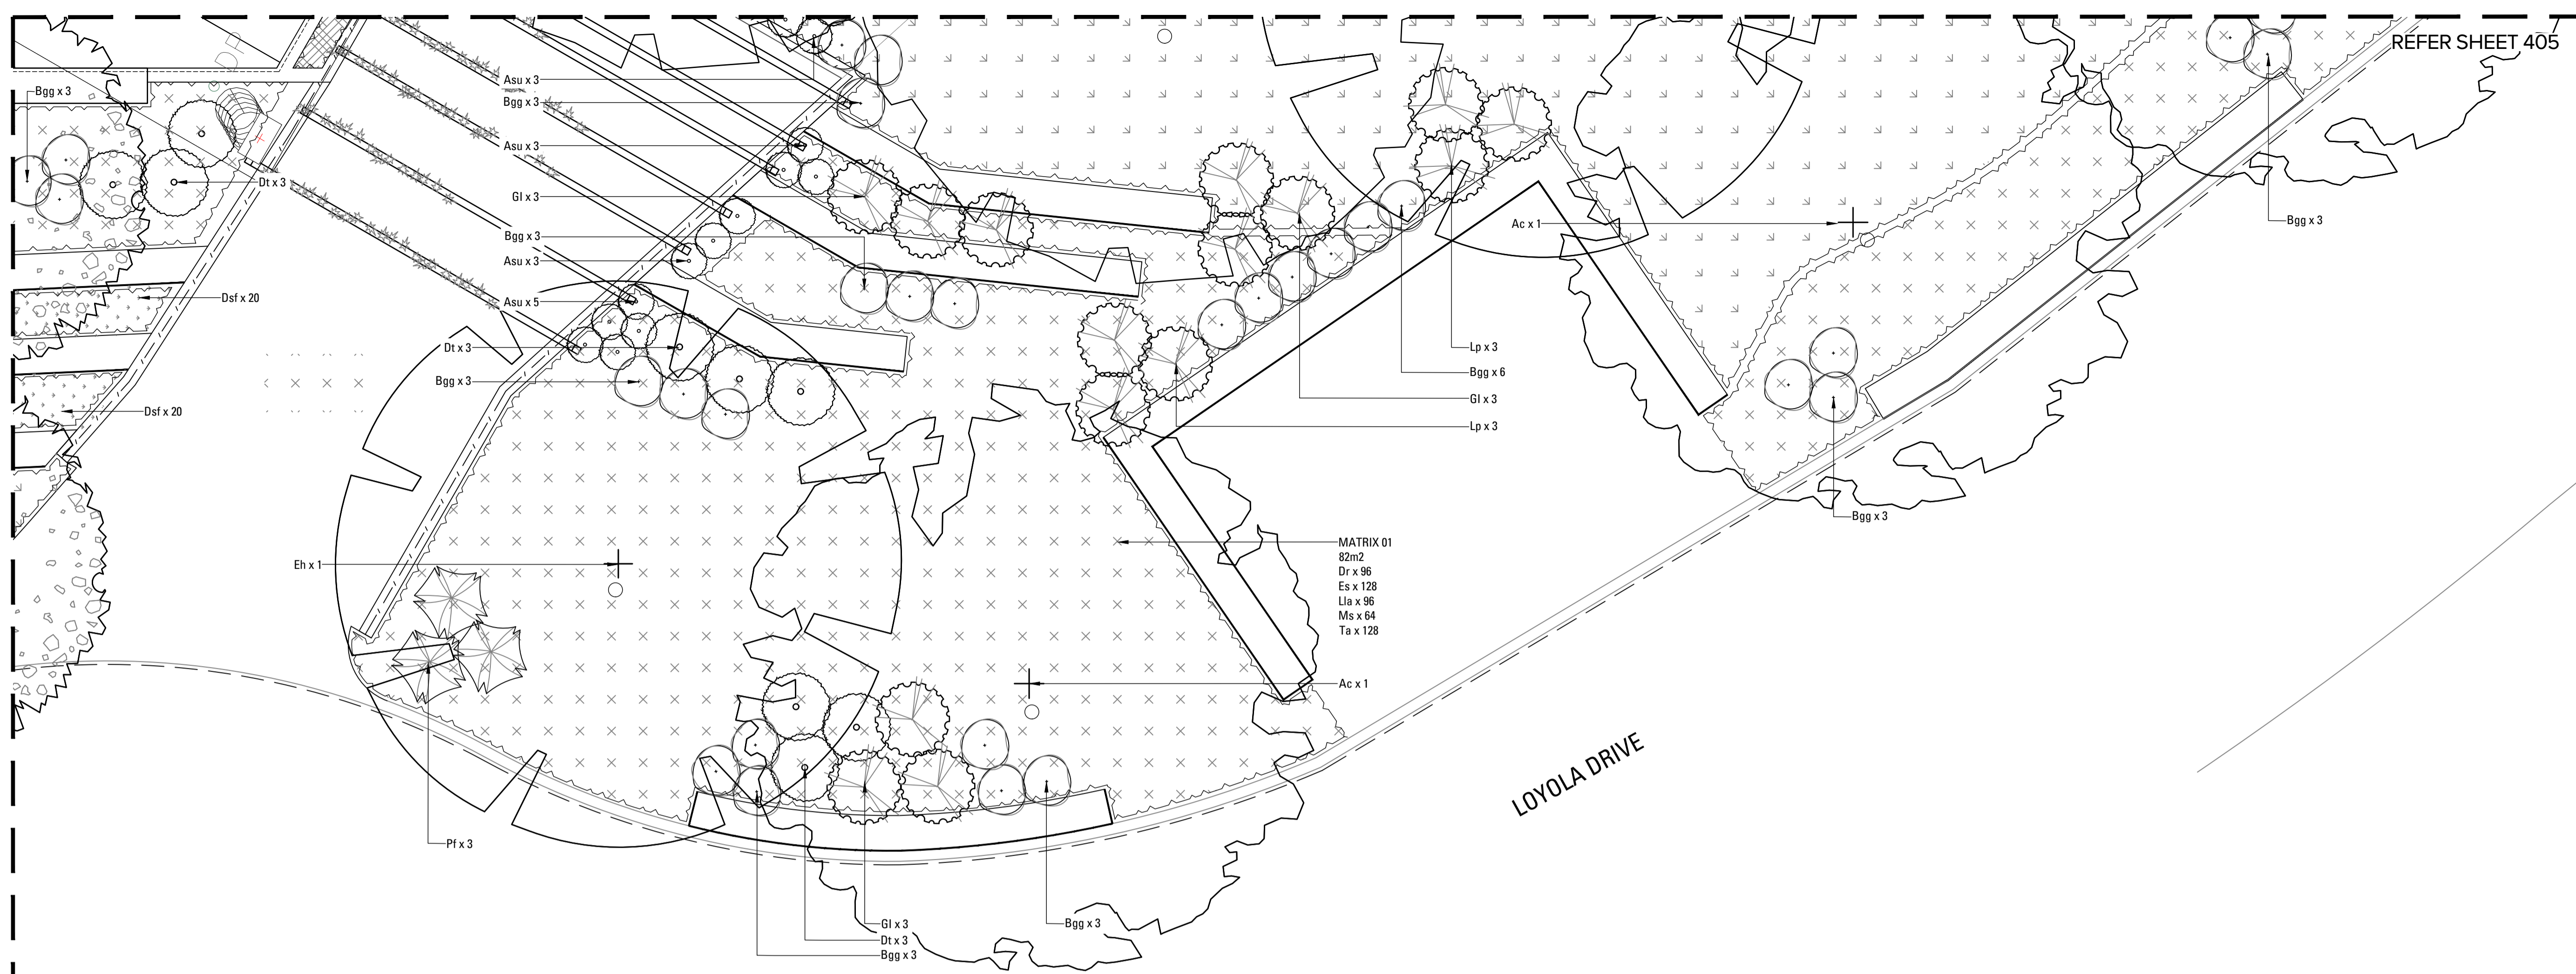

- SOFTWARES LEGEND**
- EXISTING TREES TO BE RETAINED
Refer Landscape Specification
 - EXISTING TREES TO BE REMOVED
Refer Landscape Specification
 - ANGOPHORA COSTATA
Refer Landscape Specification
 - BANKSIA INTEGRIFOLIA
Refer Landscape Specification
 - CERATOPETALUM GUMMIFERUM
Refer Landscape Specification
 - EUCALYPTUS HAEMASTOMA
Refer Landscape Specification
 - FICUS RUBIGINOSA
Refer Landscape Specification
 - LOPHOSTEMON CONFERTUS
Refer Landscape Specification
 - SHRUB AND ACCENT PLANTING
Refer Landscape Specification
 - GROUNDCOVER PLANTING
Refer Landscape Specification
 - MATRIX 1
Refer Landscape Specification
 - MATRIX 2
Refer Landscape Specification

LOYOLA DRIVE

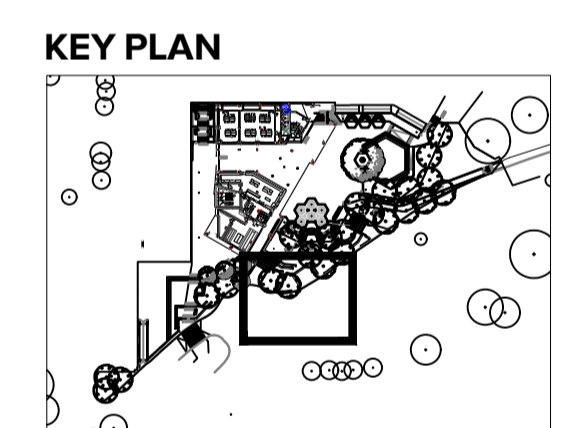

Issue	Revision Description	Drawn	Check	Date
8	FOR TENDER	CL	AL	14.09.22
7	FOR TENDER	CL	AL	09.09.22
6	FOR TENDER	LM	AL	15.08.22
5	For Coordination	LM	AL	25.07.22
4	For Coordination	LM	AL	21.07.22
3	For Coordination	LM	AL	15.07.22
2	65% For coordination	LM	AL	04.07.22
1	65% DD	LM	AL	20.05.22

Not for Construction

Project
ST IGNATIUS RIVERVIEW S2
 LANE COVE NSW
 FOR TENDER



Drawing No. 408 Drawing Name SOFTWORKS 8

Job No. 19-655 Issue 8 Scale 1:50 A1


Sydney, Suite 76, Jones Bay Wharf, 26-32 Pirrama Road, Pyrmont NSW 2009 E:sydney@arcadia.com.au T:02 8571 2900




Copyright remains the property of Arcadia Design Group Pty Ltd. Use only figured dimensions. Any other required dimensions are to be referred to and supplied by the landscape architect. All discrepancies to be referred to the project manager and Arcadia Design Group Pty Ltd prior to construction. Ensure compliance with the Building Code of Australia and all relevant Australian Standards and Authority requirements.

REFER SHEET 407

REFER SHEET 410

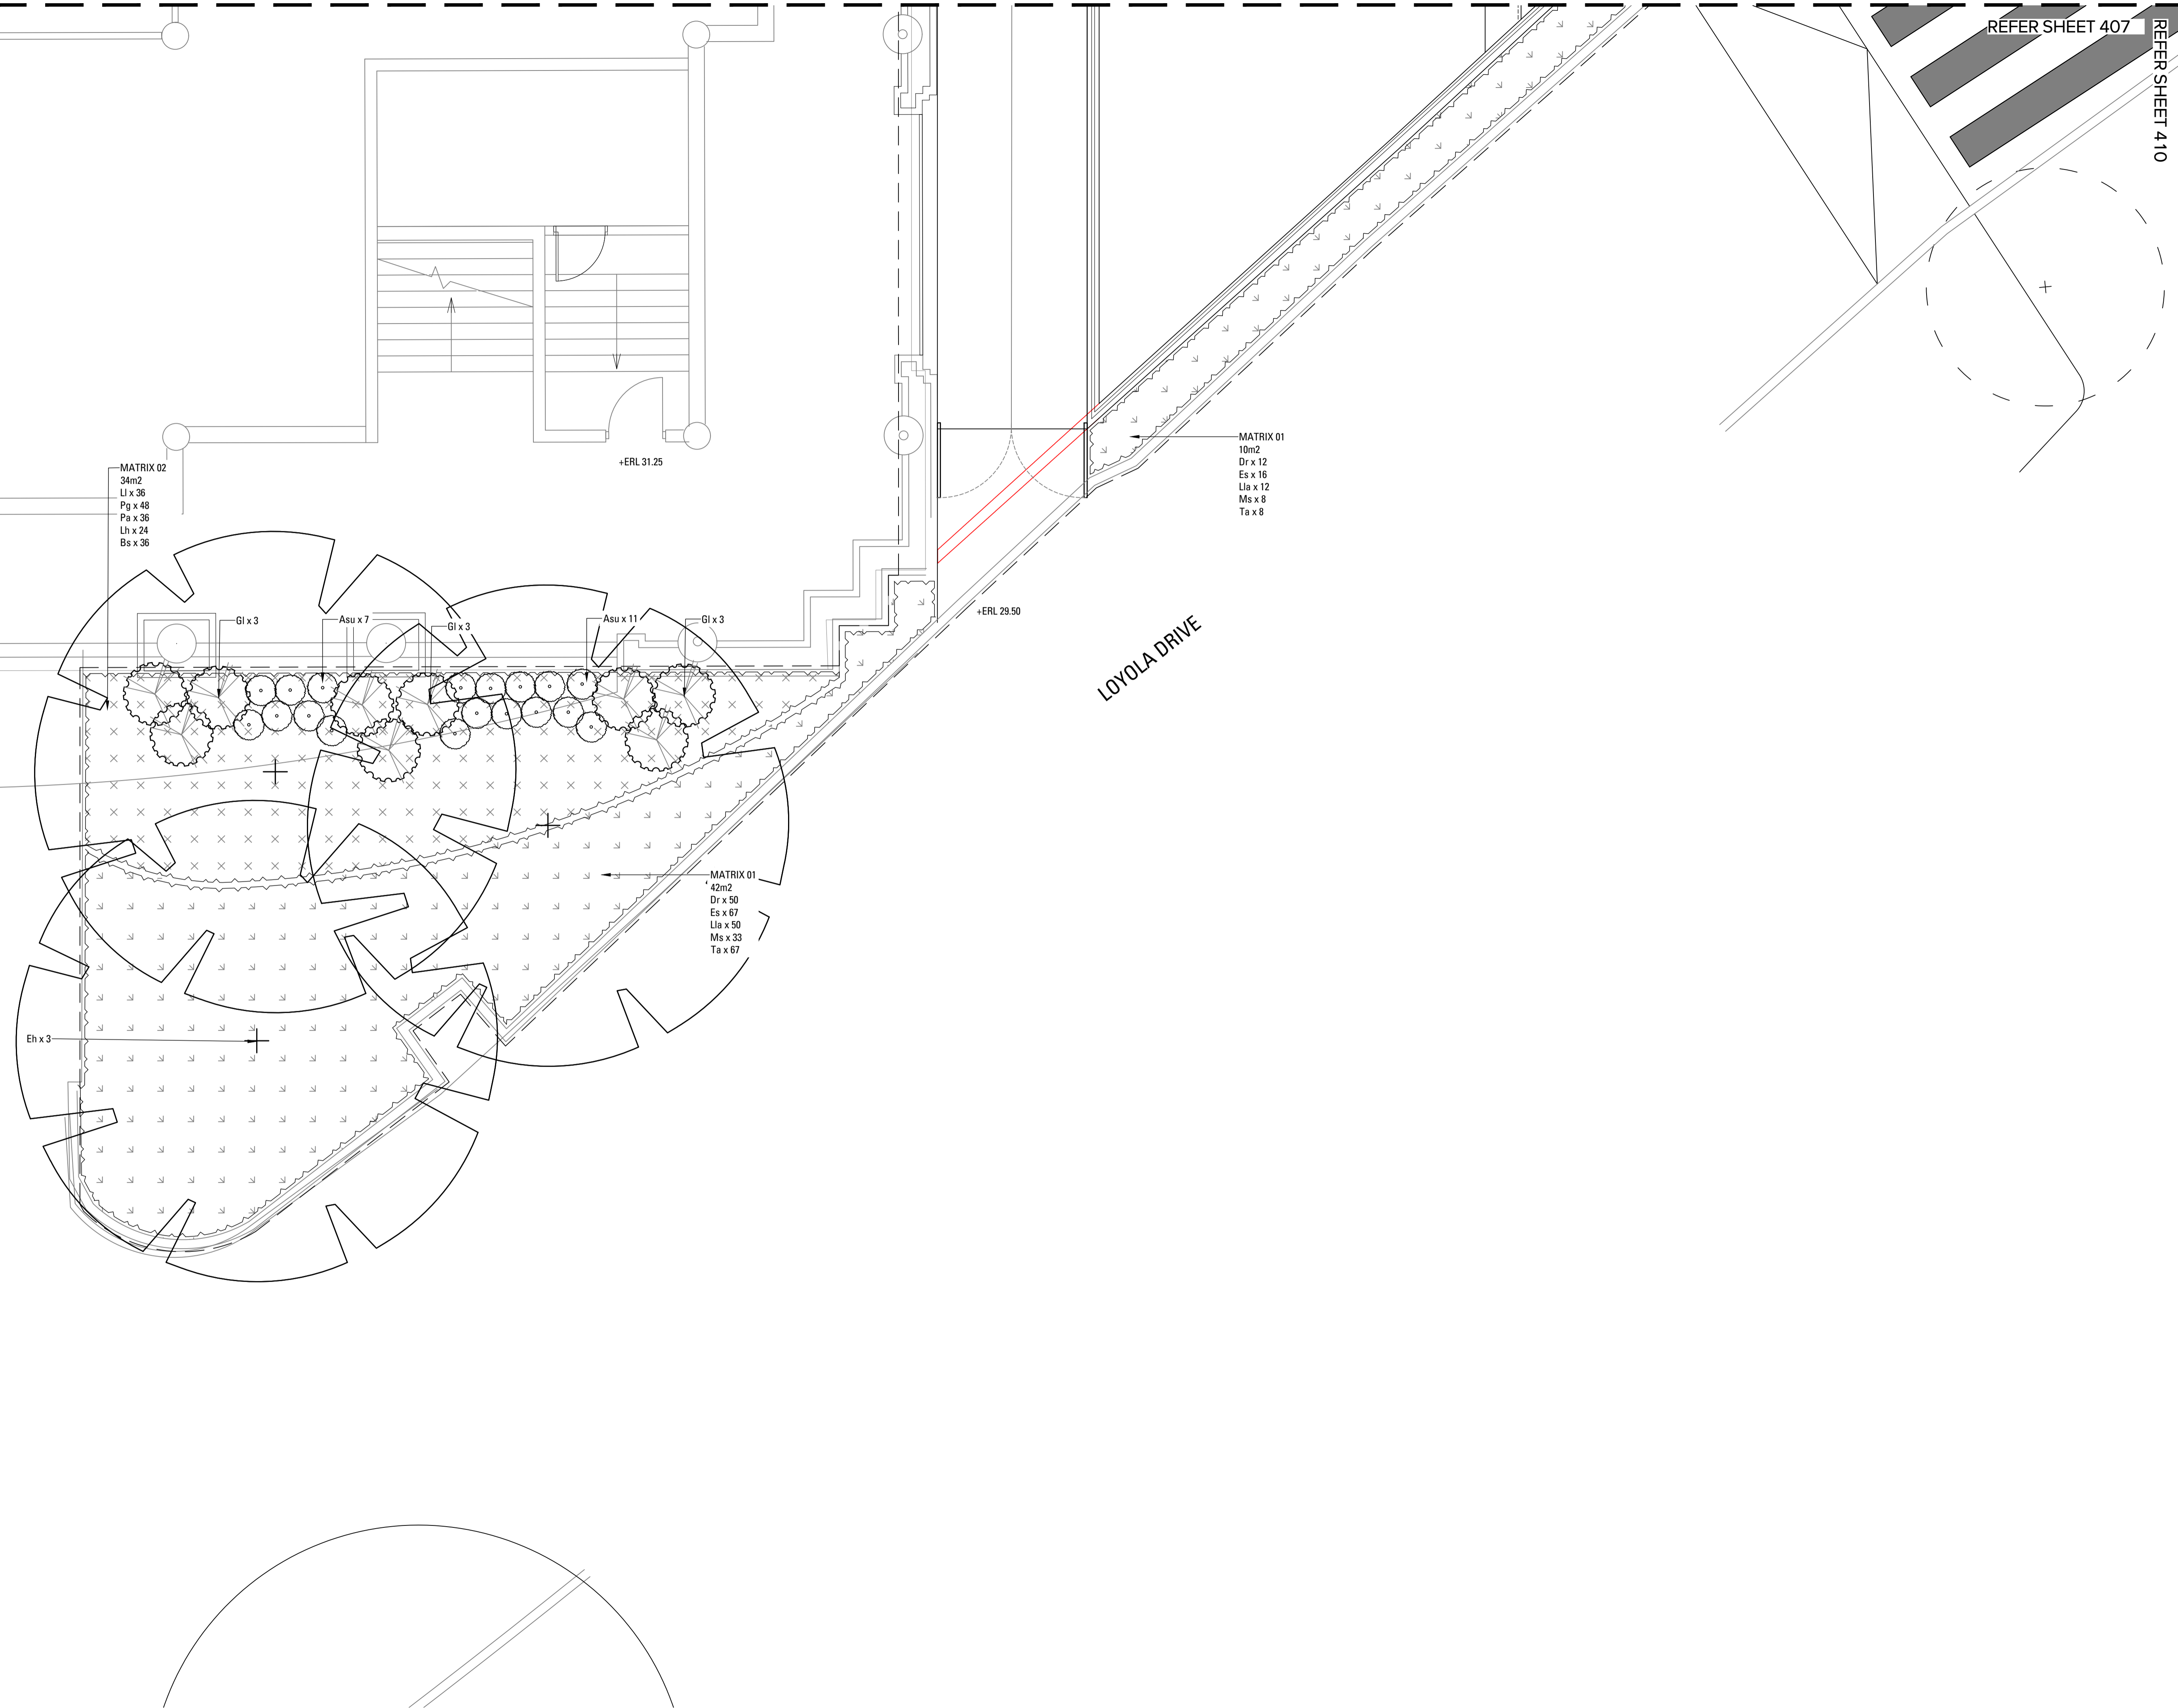

- SOFTWORKS LEGEND**
- EXISTING TREES TO BE RETAINED
Refer Landscape Specification
 - EXISTING TREES TO BE REMOVED
Refer Landscape Specification
 - ANGOPHORA COSTATA
Refer Landscape Specification
 - BANKSIA INTEGRIFOLIA
Refer Landscape Specification
 - CERATOPETALUM GUMMIFERUM
Refer Landscape Specification
 - EUCALYPTUS HAEMASTOMA
Refer Landscape Specification
 - FICUS RUBIGINOSA
Refer Landscape Specification
 - LOPHOSTEMON CONFERTUS
Refer Landscape Specification
 - SHRUB AND ACCENT PLANTING
Refer Landscape Specification
 - GROUNDCOVER PLANTING
Refer Landscape Specification
 - MATRIX 1
Refer Landscape Specification
 - MATRIX 2
Refer Landscape Specification

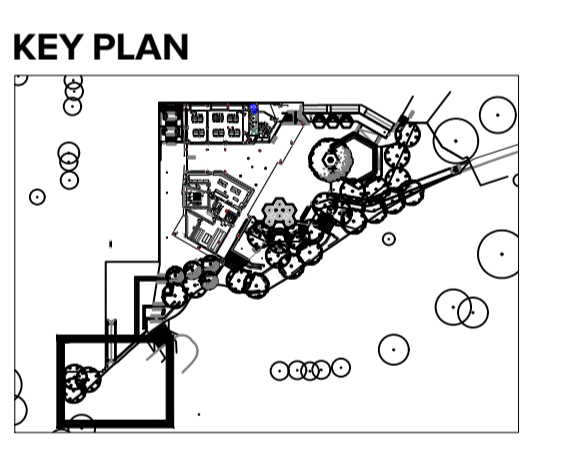

Issue	Revision	Description	Drawn	Check	Date
8		FOR TENDER	CL	AL	14.09.22
7		FOR TENDER	CL	AL	09.09.22
6		FOR TENDER	LM	AL	15.08.22
5		For Coordination	LM	AL	25.07.22
4		For Coordination	LM	AL	21.07.22
3		For Coordination	LM	AL	15.07.22
2		65% For coordination	LM	AL	04.07.22
1		65% DD	LM	AL	20.05.22

Issue Revision Description Drawn Check Date

Not for Construction

Project
ST IGNATIUS RIVERVIEW S2
 LANE COVE NSW
 FOR TENDER



Drawing No. 409 Drawing Name SOFTWORKS 9

Job No. 19-655 Issue 8 Scale 1:50 A1

Sydney, Suite 76, Jones Bay Wharf, 26-32 Pirrama Road, Pyrmont NSW 2009
 E: sydney@arcadiad.com.au
 T: 02 8571 2900

